


SCHOOL No.04

PRE-ELEMENTARY - ELEMENTARY - INTERMEDIATE
& SECONDARY SCHOOL

ASSESSMENT ARCHITECTURAL DRAWINGS

L2019-02

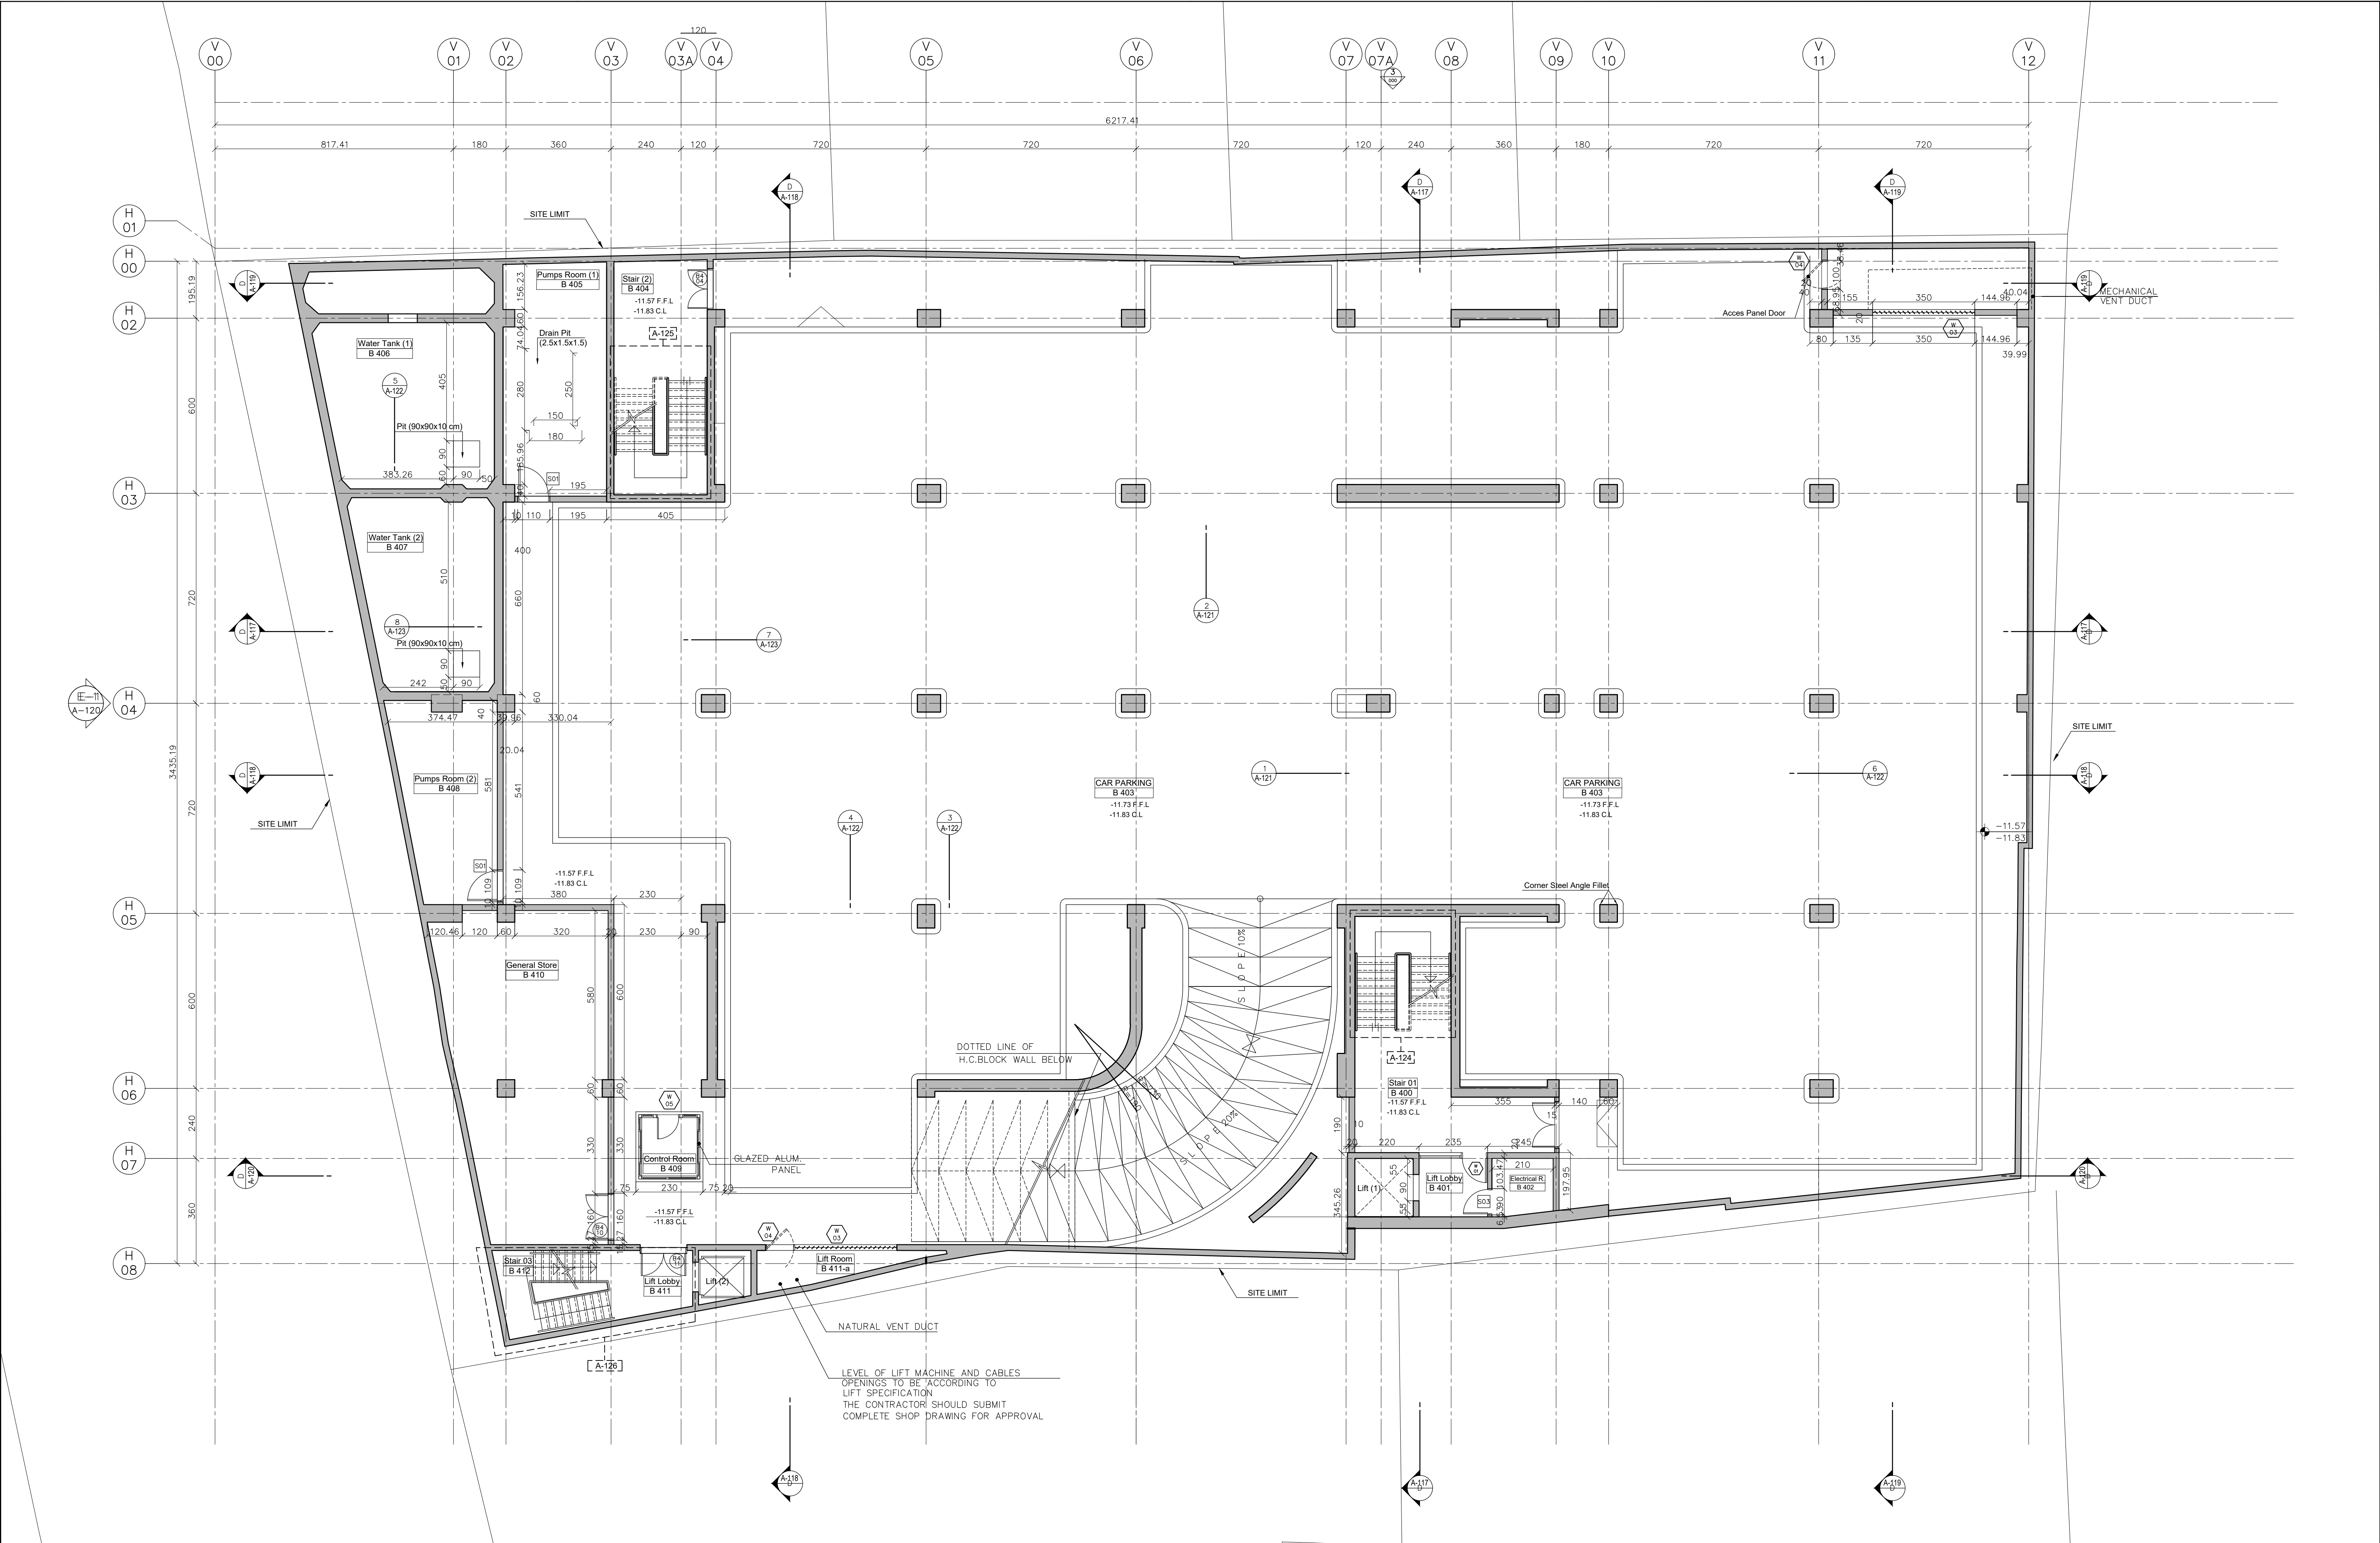

NB: REPRODUCTION AND USE OF THESE DOCUMENTS IS PROHIBITED WITHOUT WRITTEN PERMISSION OF THE DESIGNER

REVISIONS	No.	BY	DATE
1 - XXXXX	Rev1	X.X	X/XX/XX
2 - XXXXX	Rev2	X.X	X/XX/XX
3 - XXXXX	Rev3	X.X	X/XX/XX
4 - XXXXX	Rev4	X.X	X/XX/XX
5 - XXXXX	Rev5	X.X	X/XX/XX
6 - XXXXX	Rev6	X.X	X/XX/XX

LEGEND
1 - XXXXX
2 - XXXXX
3 - XXXXX
4 - XXXXX
5 - XXXXX
6 - XXXXX

سبكتروم للاستشارات الهندسية ش.م.ع.
SPECTRUM ENGINEERING CONSULTANTS s.a.r.l.

TEL: +961 1 345603-345604 - CEL: +961 3 201893 - TELEFAX: +961 1 345605
P.O.BOX: 114/50229 - BEIRUT - LEBANON
http://www.spectrumlb.com - E-MAIL: spectrum@spectrumlb.com
BAHRAIN - DUBAI - IRAQ - KUWAIT - KSA - QATAR - RIYADH - UAE
YEMEN - SUDAN - ALBANIA -

REPUBLIC OF LEBANON
MINISTRY OF EDUCATION & HIGHER EDUCATION
COUNCIL FOR DEVELOPMENT & RECONSTRUCTION

PRE-ELEMENTARY - ELEMENTARY - INTERMEDIATE
& SECONDARY SCHOOL ON LOT No. 1230 - BEIRUT


SCHOOL
04


SCALE: 1/100	PAPER: A1
DATE: SEP/2026	DRAWN: --
CHECKED: --	APP'D: --
PROJ. No.: L2019-02	DWG. No.: A-001
APP'D FOR CONSTRUCTION :	
COMPUTER CODE No.	XX-XXXX

SCALE:	1/100	PAPER	A1
DATE:	SEP/2026	DRAWN:	--
CHECKED:	--	APP'D:	--
PROJ. No.: L2019-02		DWG. No.: A-003	
APP'D FOR CONSTRUCTION :			
COMPUTER CODE No.		XX-AXXX	

SCALE:	1/100	PAPER	A1
DATE:	SEP/2026	DRAWN:	--
CHECKED:	--	APP'D:	--
PROJ. No.: L2019-02		DWG. No.: A-004	
APP'D FOR CONSTRUCTION :			
COMPUTER CODE No.		XX-AXXX	


SCALE:	1/100	PAPER	A1
DATE:	SEP/2026	DRAWN:	--
CHECKED:	--	APP'D:	--
PROJ. No.: L2019-02		DWG. No.: A-005	
APP'D FOR CONSTRUCTION :			
COMPUTER CODE No.		XX-XXXX	

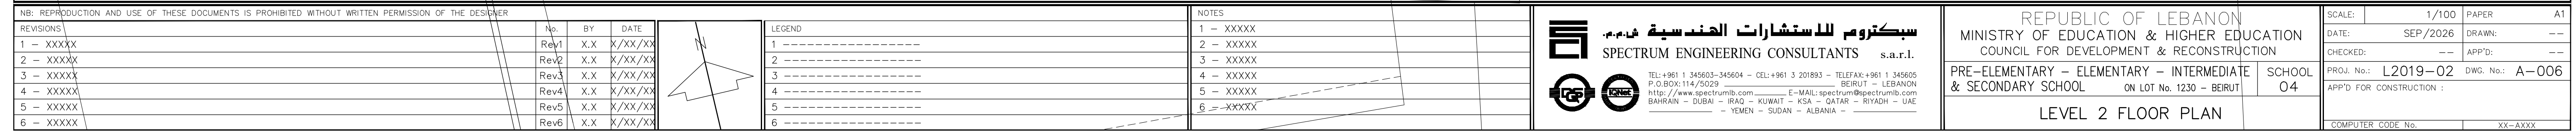

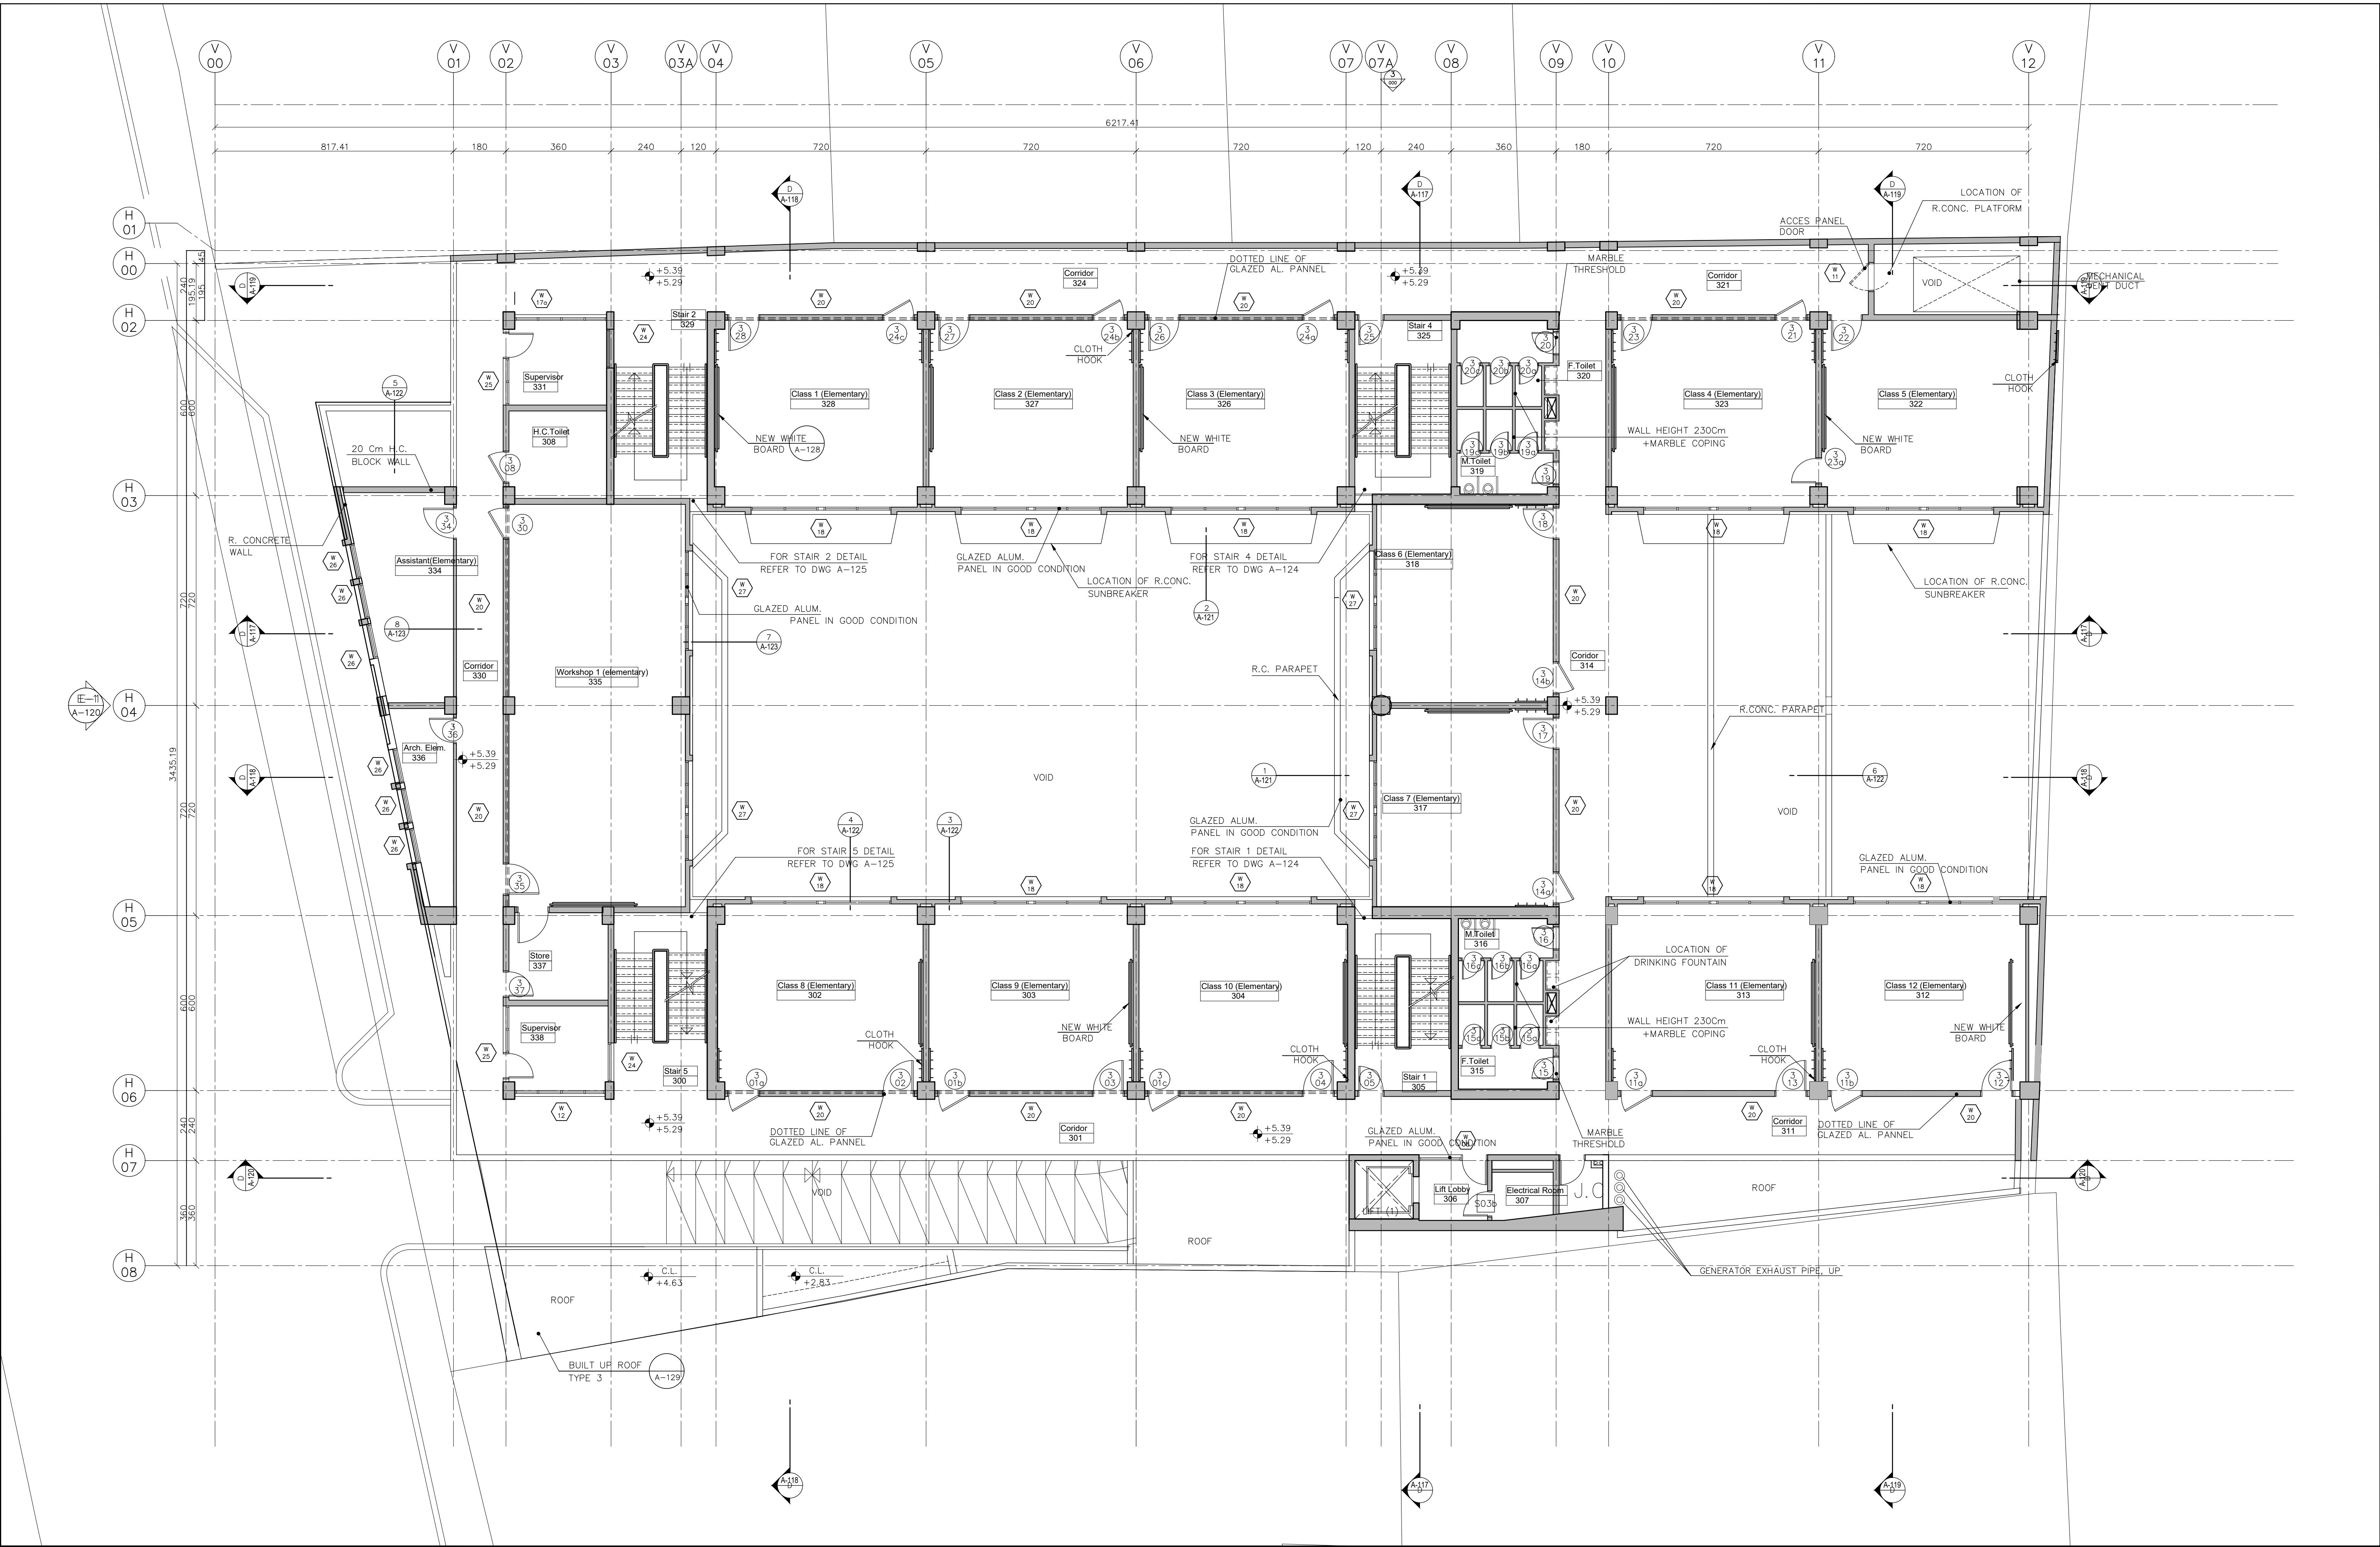

NB: REPRODUCTION AND USE OF THESE DOCUMENTS IS PROHIBITED WITHOUT WRITTEN PERMISSION OF THE DESIGNER

REVISIONS	No.	BY	DATE
1 - XXXXX	Rev1	X.X	X/XX/XX
2 - XXXXX	Rev2	X.X	X/XX/XX
3 - XXXXX	Rev3	X.X	X/XX/XX
4 - XXXXX	Rev4	X.X	X/XX/XX
5 - XXXXX	Rev5	X.X	X/XX/XX
6 - XXXXX	Rev6	X.X	X/XX/XX

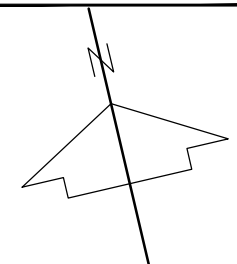

LEGEND
1 - XXXXX
2 - XXXXX
3 - XXXXX
4 - XXXXX
5 - XXXXX
6 - XXXXX

NOTES
1 - XXXXX
2 - XXXXX
3 - XXXXX
4 - XXXXX
5 - XXXXX
6 - XXXXX

NOTES
1 - XXXXX
2 - XXXXX
3 - XXXXX
4 - XXXXX
5 - XXXXX
6 - XXXXX

NOTES
1 - XXXXX
2 - XXXXX
3 - XXXXX
4 - XXXXX
5 - XXXXX
6 - XXXXX

NOTES
1 - XXXXX
2 - XXXXX
3 - XXXXX
4 - XXXXX
5 - XXXXX
6 - XXXXX

NOTES
1 - XXXXX
2 - XXXXX
3 - XXXXX
4 - XXXXX
5 - XXXXX
6 - XXXXX

NOTES
1 - XXXXX
2 - XXXXX
3 - XXXXX
4 - XXXXX
5 - XXXXX
6 - XXXXX

NOTES
1 - XXXXX
2 - XXXXX
3 - XXXXX
4 - XXXXX
5 - XXXXX
6 - XXXXX

NOTES
1 - XXXXX
2 - XXXXX
3 - XXXXX
4 - XXXXX
5 - XXXXX
6 - XXXXX

NOTES
1 - XXXXX
2 - XXXXX
3 - XXXXX
4 - XXXXX
5 - XXXXX
6 - XXXXX

NOTES
1 - XXXXX
2 - XXXXX
3 - XXXXX
4 - XXXXX
5 - XXXXX
6 - XXXXX

NOTES
1 - XXXXX
2 - XXXXX
3 - XXXXX
4 - XXXXX
5 - XXXXX
6 - XXXXX

NOTES
1 - XXXXX
2 - XXXXX
3 - XXXXX
4 - XXXXX
5 - XXXXX
6 - XXXXX

NOTES
1 - XXXXX
2 - XXXXX
3 - XXXXX
4 - XXXXX
5 - XXXXX
6 - XXXXX

NOTES
1 - XXXXX
2 - XXXXX
3 - XXXXX
4 - XXXXX
5 - XXXXX
6 - XXXXX

NOTES
1 - XXXXX
2 - XXXXX
3 - XXXXX
4 - XXXXX
5 - XXXXX
6 - XXXXX

NOTES
1 - XXXXX
2 - XXXXX
3 - XXXXX
4 - XXXXX
5 - XXXXX
6 - XXXXX

NOTES
1 - XXXXX
2 - XXXXX
3 - XXXXX
4 - XXXXX
5 - XXXXX
6 - XXXXX

NOTES
1 - XXXXX
2 - XXXXX
3 - XXXXX
4 - XXXXX
5 - XXXXX
6 - XXXXX

NOTES
1 - XXXXX
2 - XXXXX
3 - XXXXX
4 - XXXXX
5 - XXXXX
6 - XXXXX

NOTES
1 - XXXXX
2 - XXXXX
3 - XXXXX
4 - XXXXX
5 - XXXXX
6 - XXXXX

NOTES
1 - XXXXX
2 - XXXXX
3 - XXXXX
4 - XXXXX
5 - XXXXX
6 - XXXXX

NOTES
1 - XXXXX
2 - XXXXX
3 - XXXXX
4 - XXXXX
5 - XXXXX
6 - XXXXX

NOTES
1 - XXXXX
2 - XXXXX
3 - XXXXX
4 - XXXXX
5 - XXXXX
6 - XXXXX

NOTES
1 - XXXXX
2 - XXXXX
3 - XXXXX
4 - XXXXX
5 - XXXXX
6 - XXXXX

NOTES
1 - XXXXX
2 - XXXXX
3 - XXXXX
4 - XXXXX
5 - XXXXX
6 - XXXXX

NOTES
1 - XXXXX
2 - XXXXX
3 - XXXXX
4 - XXXXX
5 - XXXXX
6 - XXXXX

NOTES
1 - XXXXX
2 - XXXXX
3 - XXXXX
4 - XXXXX
5 - XXXXX
6 - XXXXX

NOTES
1 - XXXXX
2 - XXXXX
3 - XXXXX
4 - XXXXX
5 - XXXXX
6 - XXXXX

NOTES
1 - XXXXX
2 - XXXXX
3 - XXXXX
4 - XXXXX
5 - XXXXX
6 - XXXXX

NOTES
1 - XXXXX
2 - XXXXX
3 - XXXXX
4 - XXXXX
5 - XXXXX
6 - XXXXX

NOTES
1 - XXXXX
2 - XXXXX
3 - XXXXX
4 - XXXXX
5 - XXXXX
6 - XXXXX

NOTES
1 - XXXXX
2 - XXXXX
3 - XXXXX
4 - XXXXX
5 - XXXXX
6 - XXXXX

NOTES
1 - XXXXX
2 - XXXXX
3 - XXXXX
4 - XXXXX
5 - XXXXX
6 - XXXXX

NOTES
1 - XXXXX
2 - XXXXX
3 - XXXXX
4 - XXXXX
5 - XXXXX
6 - XXXXX

NOTES
1 - XXXXX
2 - XXXXX
3 - XXXXX
4 - XXXXX
5 - XXXXX
6 - XXXXX


NOTES
1 - XXXXX
2 - XXXXX
3 - XXXXX
4 - XXXXX
5 - XXXXX
6 - XXXXX

NOTES
1 - XXXXX
2 - XXXXX
3 - XXXXX
4 - XXXXX
5 - XXXXX
6 - XXXXX

NOTES
1 - XXXXX
2 - XXXXX
3 - XXXXX
4 - XXXXX
5 - XXXXX
6 - XXXXX


NOTES
1 - XXXXX
2 - XXXXX
3 - XXXXX
4 - XXXXX
5 - XXXXX
6 - XXXXX

NOTES
1 - XXXXX
2 - XXXXX
3 - XXXXX
4 - XXXXX
5 - XXXXX
6 - XXXXX

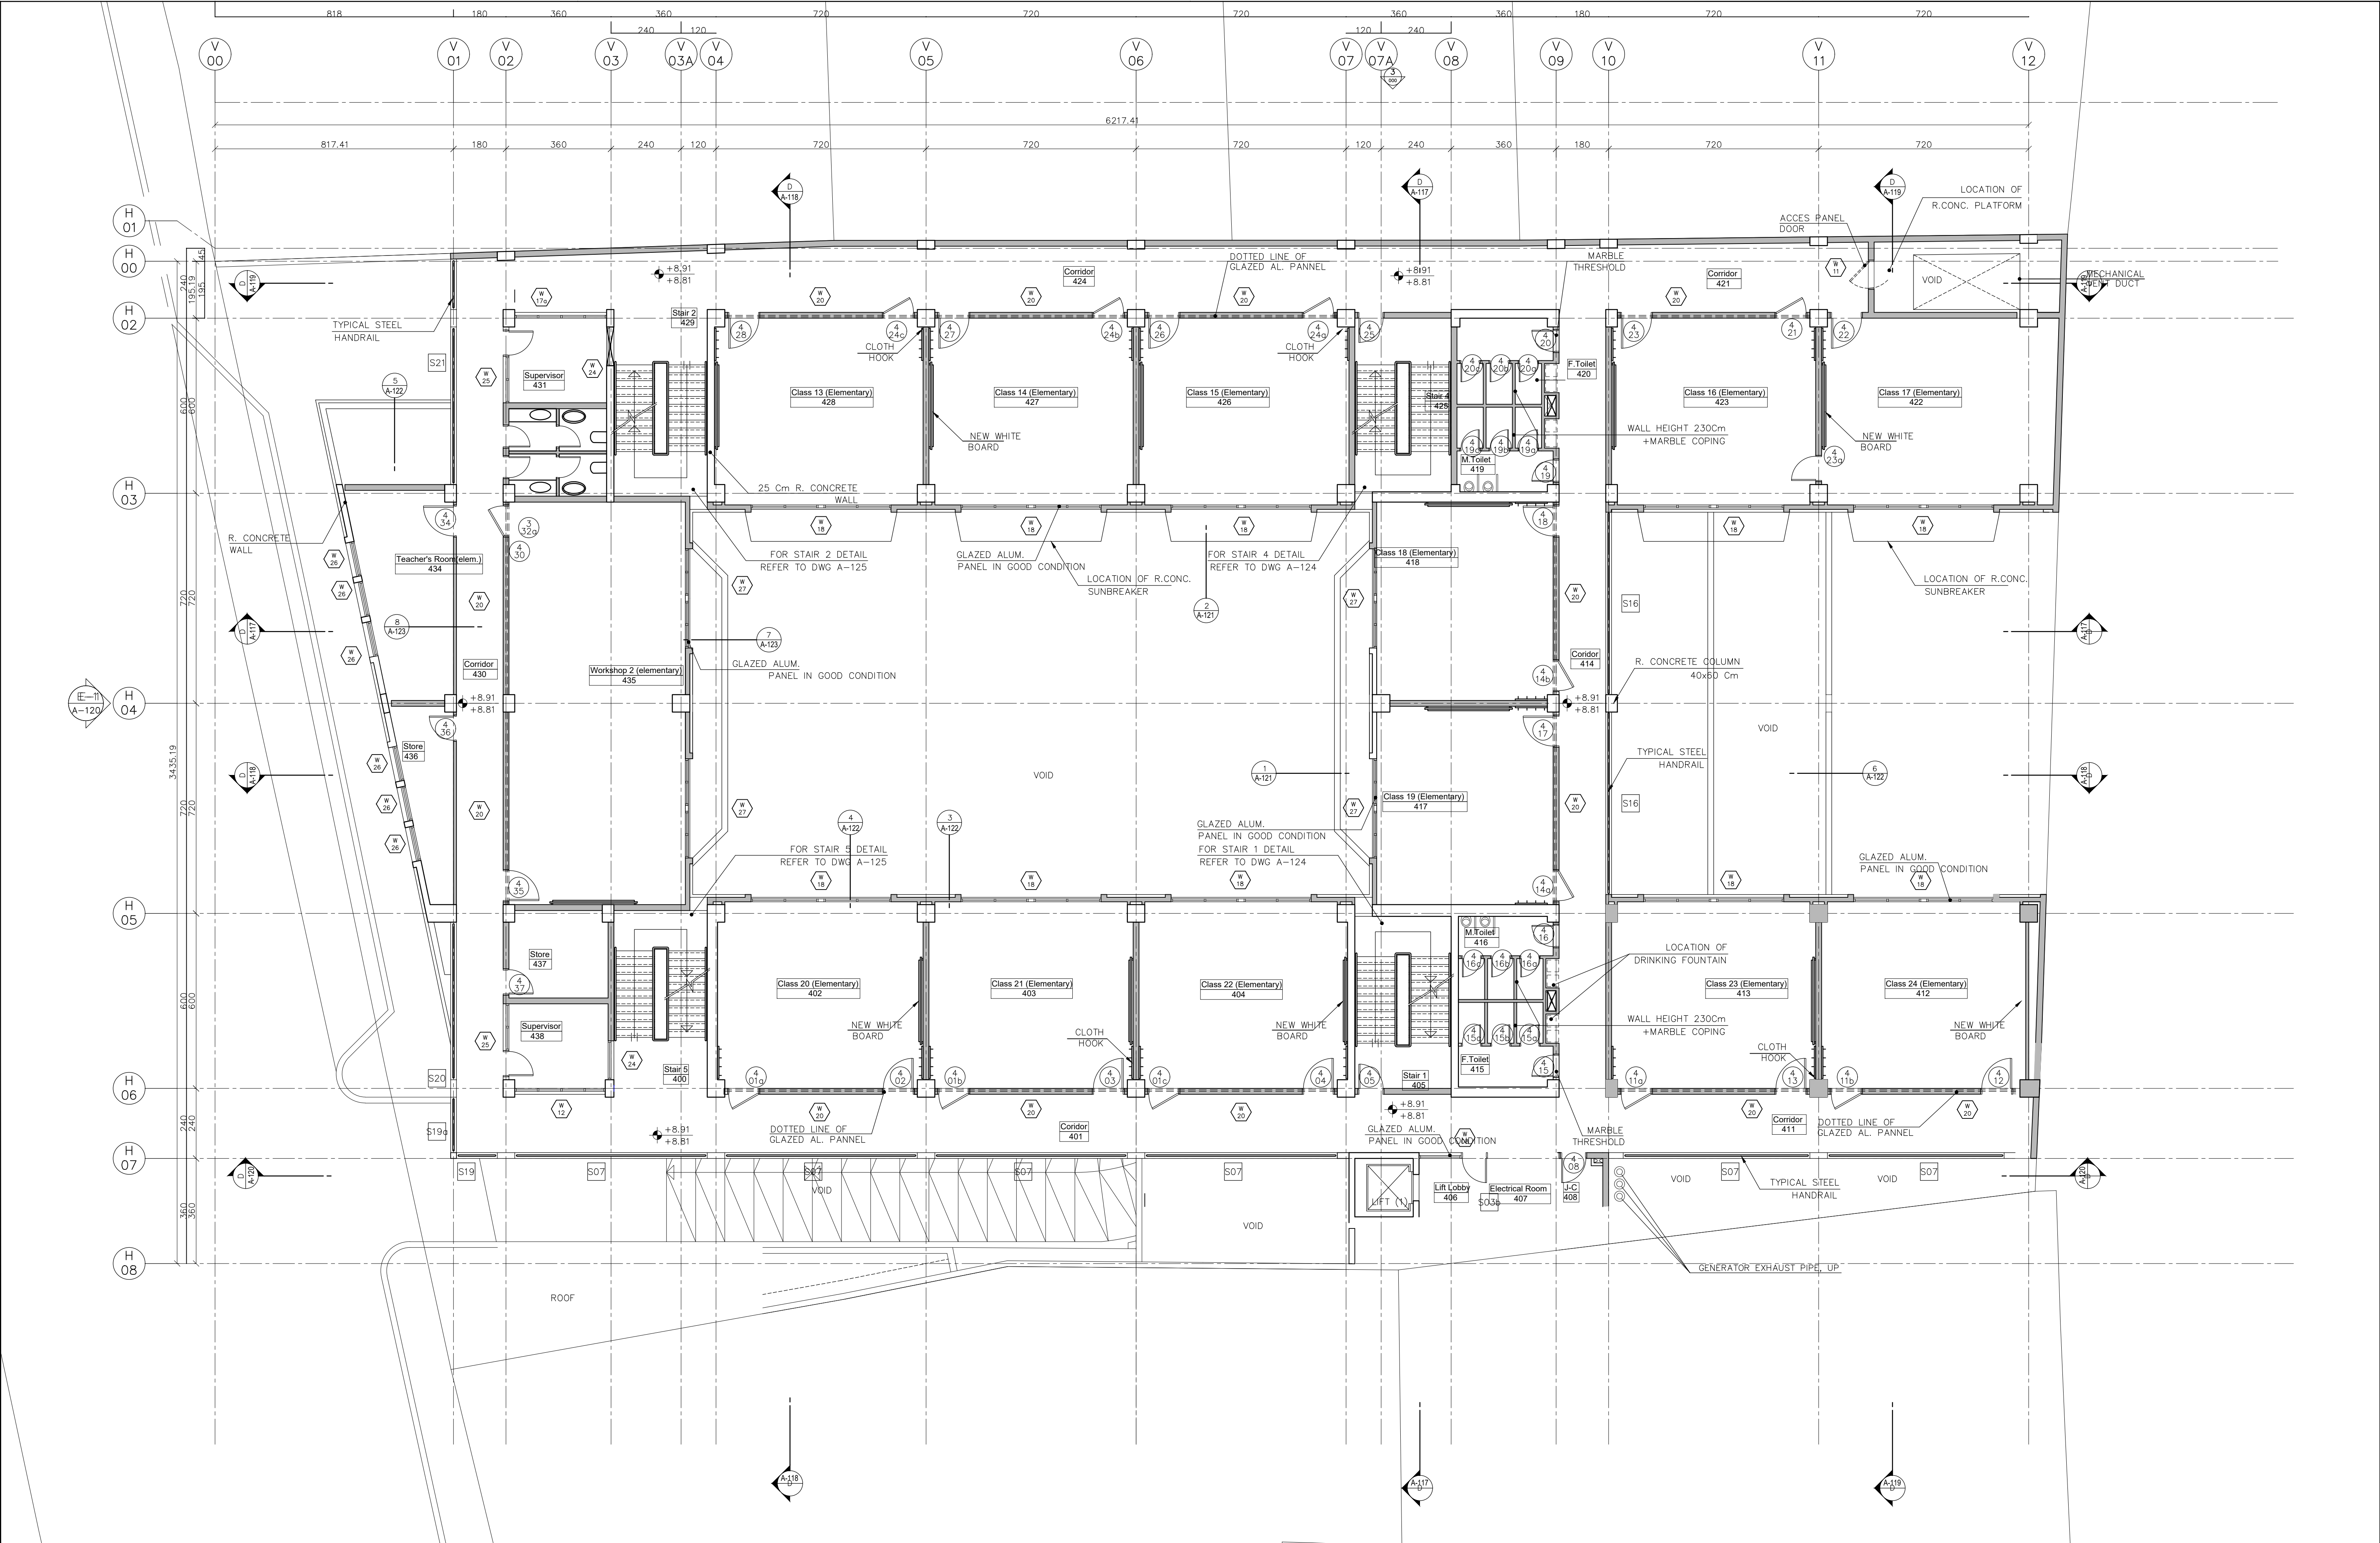

NB: REPRODUCTION AND USE OF THESE DOCUMENTS IS PROHIBITED WITHOUT WRITTEN PERMISSION OF THE DESIGNER

REVISIONS	No.	BY	DATE
1 - XXXXX	Rev1	X.X	X/XX/XX
2 - XXXXX	Rev2	X.X	X/XX/XX
3 - XXXXX	Rev3	X.X	X/XX/XX
4 - XXXXX	Rev4	X.X	X/XX/XX
5 - XXXXX	Rev5	X.X	X/XX/XX
6 - XXXXX	Rev6	X.X	X/XX/XX

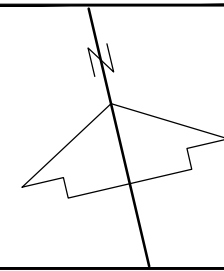

LEGEND
1 - XXXXX
2 - XXXXX
3 - XXXXX
4 - XXXXX
5 - XXXXX
6 - XXXXX


NOTES
1 - XXXXX
2 - XXXXX
3 - XXXXX
4 - XXXXX
5 - XXXXX
6 - XXXXX

**سبكتروم للاستشارات الهندسية ش.م.ع.**
SPECTRUM ENGINEERING CONSULTANTS s.a.r.l.
TEL: +961 1 345603-345604 - CEL: +961 3 201893 - TELEFAX: +961 1 345605
P.O.BOX: 114/5029 - BEIRUT - LEBANON
http://www.spectrumlb.com E-MAIL: spectrum@spectrumlb.com
BAHRAIN - DUBAI - IRAQ - KUWAIT - KSA - QATAR - RIYADH - UAE
BAHRAIN - DUBAI - IRAQ - KUWAIT - KSA - QATAR - RIYADH - UAE

REPUBLIC OF LEBANON
MINISTRY OF EDUCATION & HIGHER EDUCATION
COUNCIL FOR DEVELOPMENT & RECONSTRUCTION
PRE-ELEMENTARY - ELEMENTARY - INTERMEDIATE
& SECONDARY SCHOOL ON LOT No. 1230 - BEIRUT


SCHOOL
04

SCALE:	1/100	PAPER:	A1
DATE:	SEP/2026	DRAWN:	--
CHECKED:	--	APP'D:	--
PROJ. No.:	L2019-02	DWG. No.:	A-008
APP'D FOR CONSTRUCTION:			
COMPUTER CODE No.	XX-XXXX		

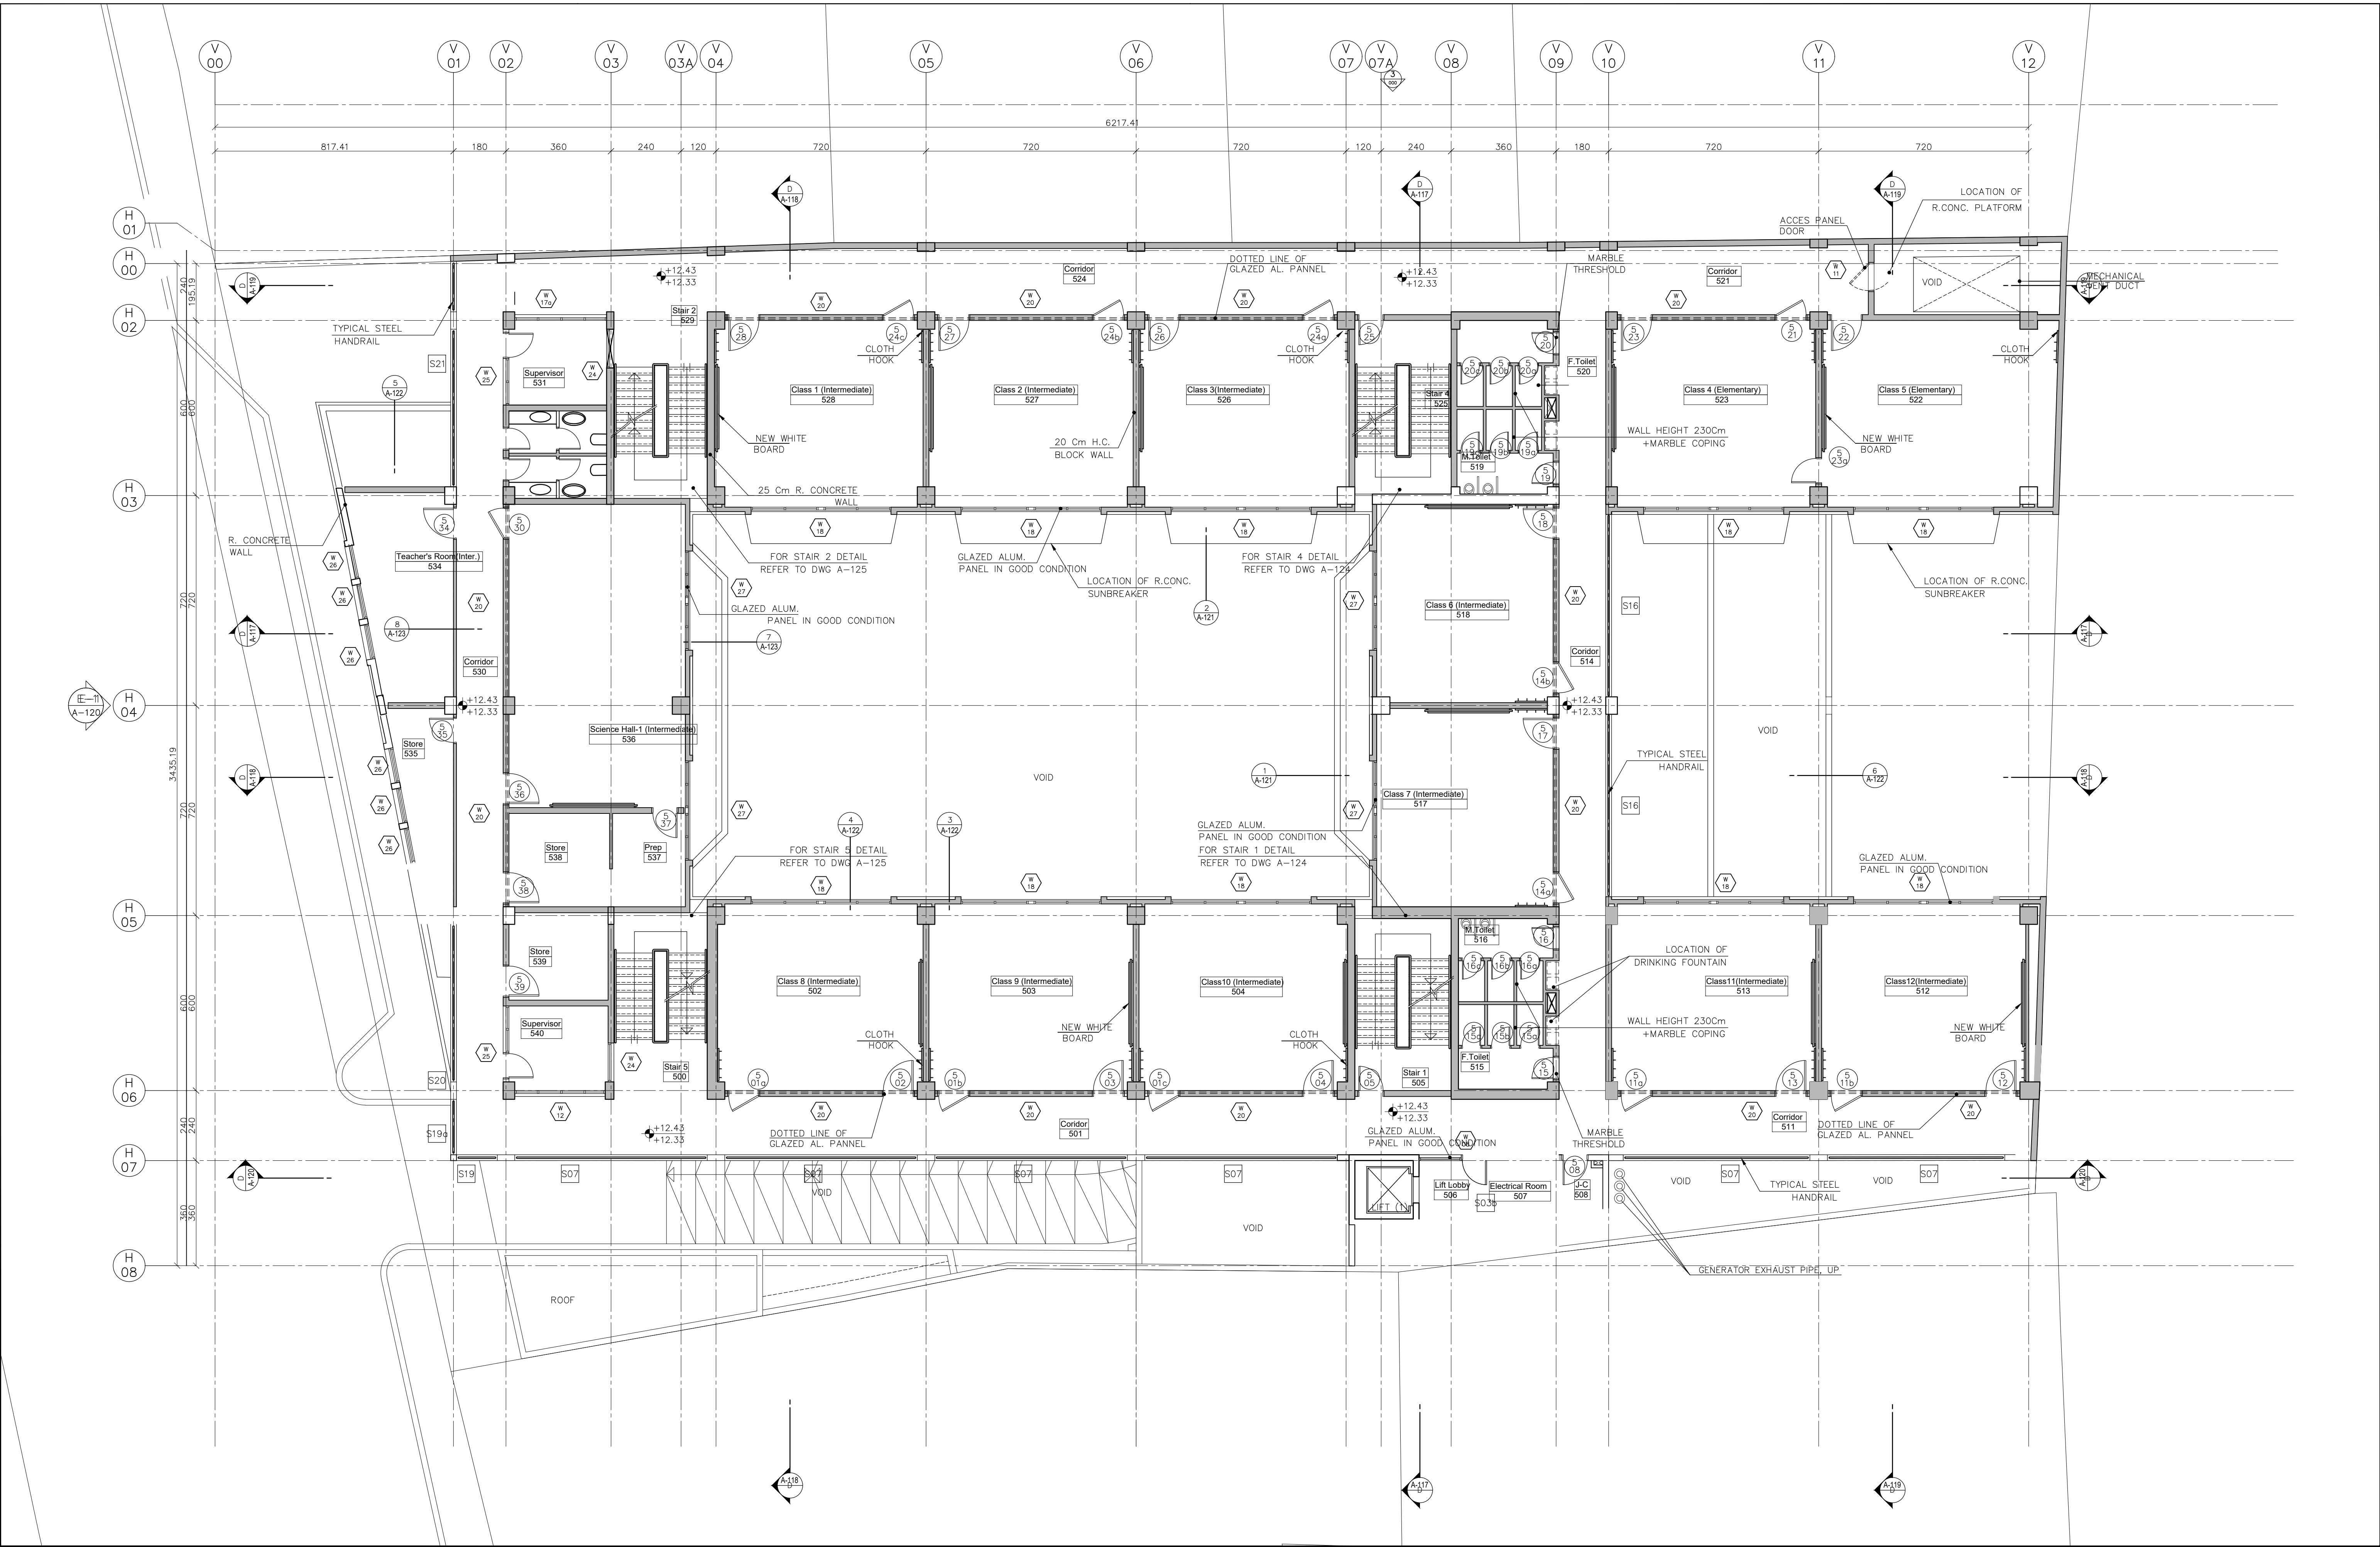

NB: REPRODUCTION AND USE OF THESE DOCUMENTS IS PROHIBITED WITHOUT WRITTEN PERMISSION OF THE DESIGNER

REVISIONS	No.	BY	DATE
1 - XXXXX	Rev1	X.X	X/XX/XX
2 - XXXXX	Rev2	X.X	X/XX/XX
3 - XXXXX	Rev3	X.X	X/XX/XX
4 - XXXXX	Rev4	X.X	X/XX/XX
5 - XXXXX	Rev5	X.X	X/XX/XX
6 - XXXXX	Rev6	X.X	X/XX/XX

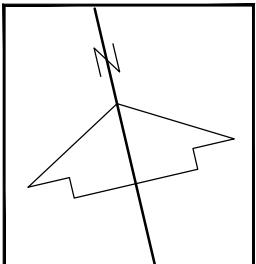

LEGEND
1 - XXXXX
2 - XXXXX
3 - XXXXX
4 - XXXXX
5 - XXXXX
6 - XXXXX

NOTES
1 - XXXXX
2 - XXXXX
3 - XXXXX
4 - XXXXX
5 - XXXXX
6 - XXXXX

سبكتروم للاستشارات الهندسية ش.م.ع.
SPECTRUM ENGINEERING CONSULTANTS s.a.r.l.

TEL: +961 1 345603-345604 - CEL: +961 3 201893 - TELEFAX: +961 1 345605
P.O.BOX: 114/5029 - BEIRUT - LEBANON
http://www.spectrumlb.com - E-MAIL: spectrum@spectrumlb.com
BAHRAIN - DUBAI - IRAQ - KUWAIT - KSA - QATAR - RIYADH - UAE
YEMEN - SUDAN - ALBANIA


REPUBLIC OF LEBANON
MINISTRY OF EDUCATION & HIGHER EDUCATION
COUNCIL FOR DEVELOPMENT & RECONSTRUCTION

PRE-ELEMENTARY - ELEMENTARY - INTERMEDIATE
& SECONDARY SCHOOL ON LOT No. 1230 - BEIRUT

SCHOOL
04


LEVEL 5 FLOOR PLAN

SCALE:	1/100	PAPER:	A1
DATE:	SEP/2026	DRAWN:	--
CHECKED:	--	APP'D:	--
PROJ. No.:	L2019-02	DWG. No.:	A-009
APP'D FOR CONSTRUCTION :			
COMPUTER CODE No.	XX-XXXX		

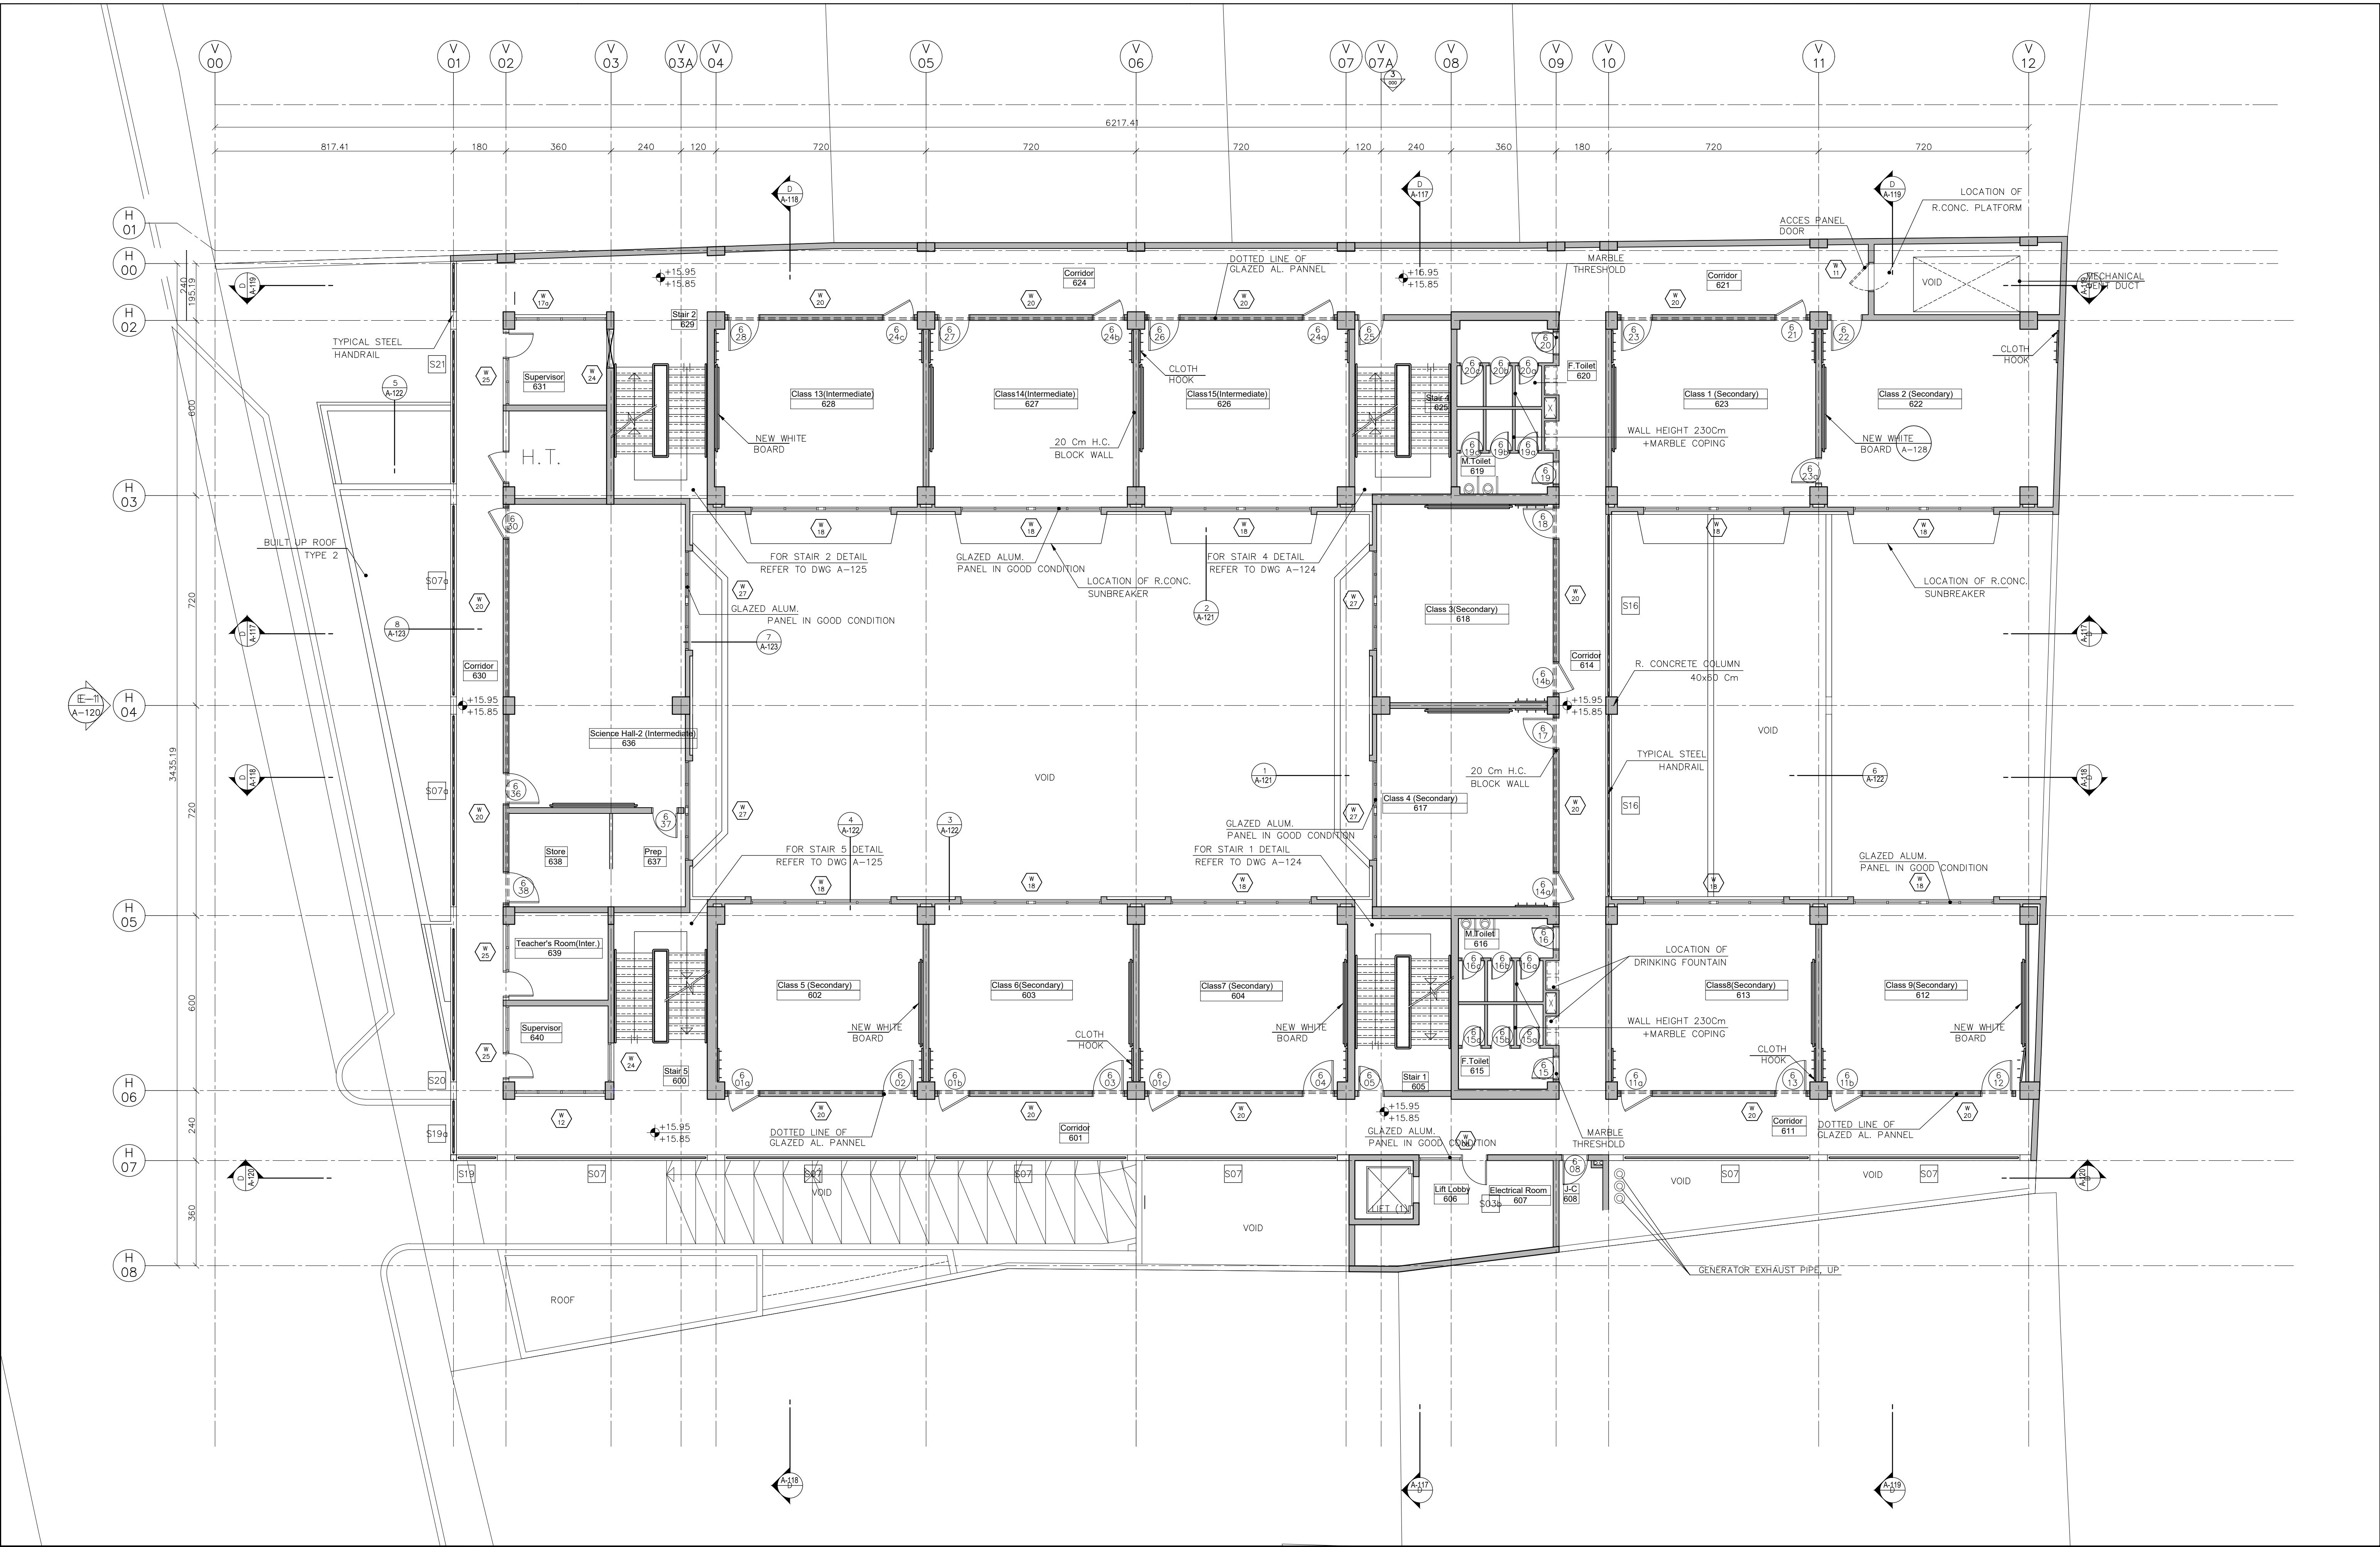

NB: REPRODUCTION AND USE OF THESE DOCUMENTS IS PROHIBITED WITHOUT WRITTEN PERMISSION OF THE DESIGNER

REVISIONS	No.	BY	DATE
1 - XXXXX	Rev1	X.X	X/XX/XX
2 - XXXXX	Rev2	X.X	X/XX/XX
3 - XXXXX	Rev3	X.X	X/XX/XX
4 - XXXXX	Rev4	X.X	X/XX/XX
5 - XXXXX	Rev5	X.X	X/XX/XX
6 - XXXXX	Rev6	X.X	X/XX/XX

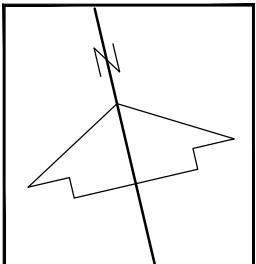

LEGEND
1 - XXXXX
2 - XXXXX
3 - XXXXX
4 - XXXXX
5 - XXXXX
6 - XXXXX

NOTES
1 - XXXXX
2 - XXXXX
3 - XXXXX
4 - XXXXX
5 - XXXXX
6 - XXXXX

سبكتروم للاستشارات الهندسية ش.م.ع.
SPECTRUM ENGINEERING CONSULTANTS s.a.r.l.

TEL: +961 1 345603-345604 - CEL: +961 3 201893 - TELEFAX: +961 1 345605
P.O.BOX: 114/5029 - BEIRUT - LEBANON
http://www.spectrumlb.com - E-MAIL: spectrum@spectrumlb.com
BAHRAIN - DUBAI - IRAQ - KUWAIT - KSA - QATAR - RIYADH - UAE
YEMEN - SUDAN - ALBANIA

REPUBLIC OF LEBANON
MINISTRY OF EDUCATION & HIGHER EDUCATION
COUNCIL FOR DEVELOPMENT & RECONSTRUCTION


PRE-ELEMENTARY - ELEMENTARY - INTERMEDIATE
& SECONDARY SCHOOL ON LOT No. 1230 - BEIRUT

SCHOOL
04

LEVEL 6 FLOOR PLAN

SCALE:	1/100	PAPER:	A1
DATE:	SEP/2026	DRAWN:	--
CHECKED:	--	APP'D:	--
PROJ. No.:	L2019-02	DWG. No.:	A-010
APP'D FOR CONSTRUCTION :			
COMPUTER CODE No.	XX-XXXX		

SCALE:	1/100	PAPER	A1
DATE:	SEP/2026	DRAWN:	--
CHECKED:	--	APP'D:	--
PROJ. No.: L2019-02		DWG. No.: A-011	
APP'D FOR CONSTRUCTION :			
COMPUTER CODE No.		XX-XXXX	

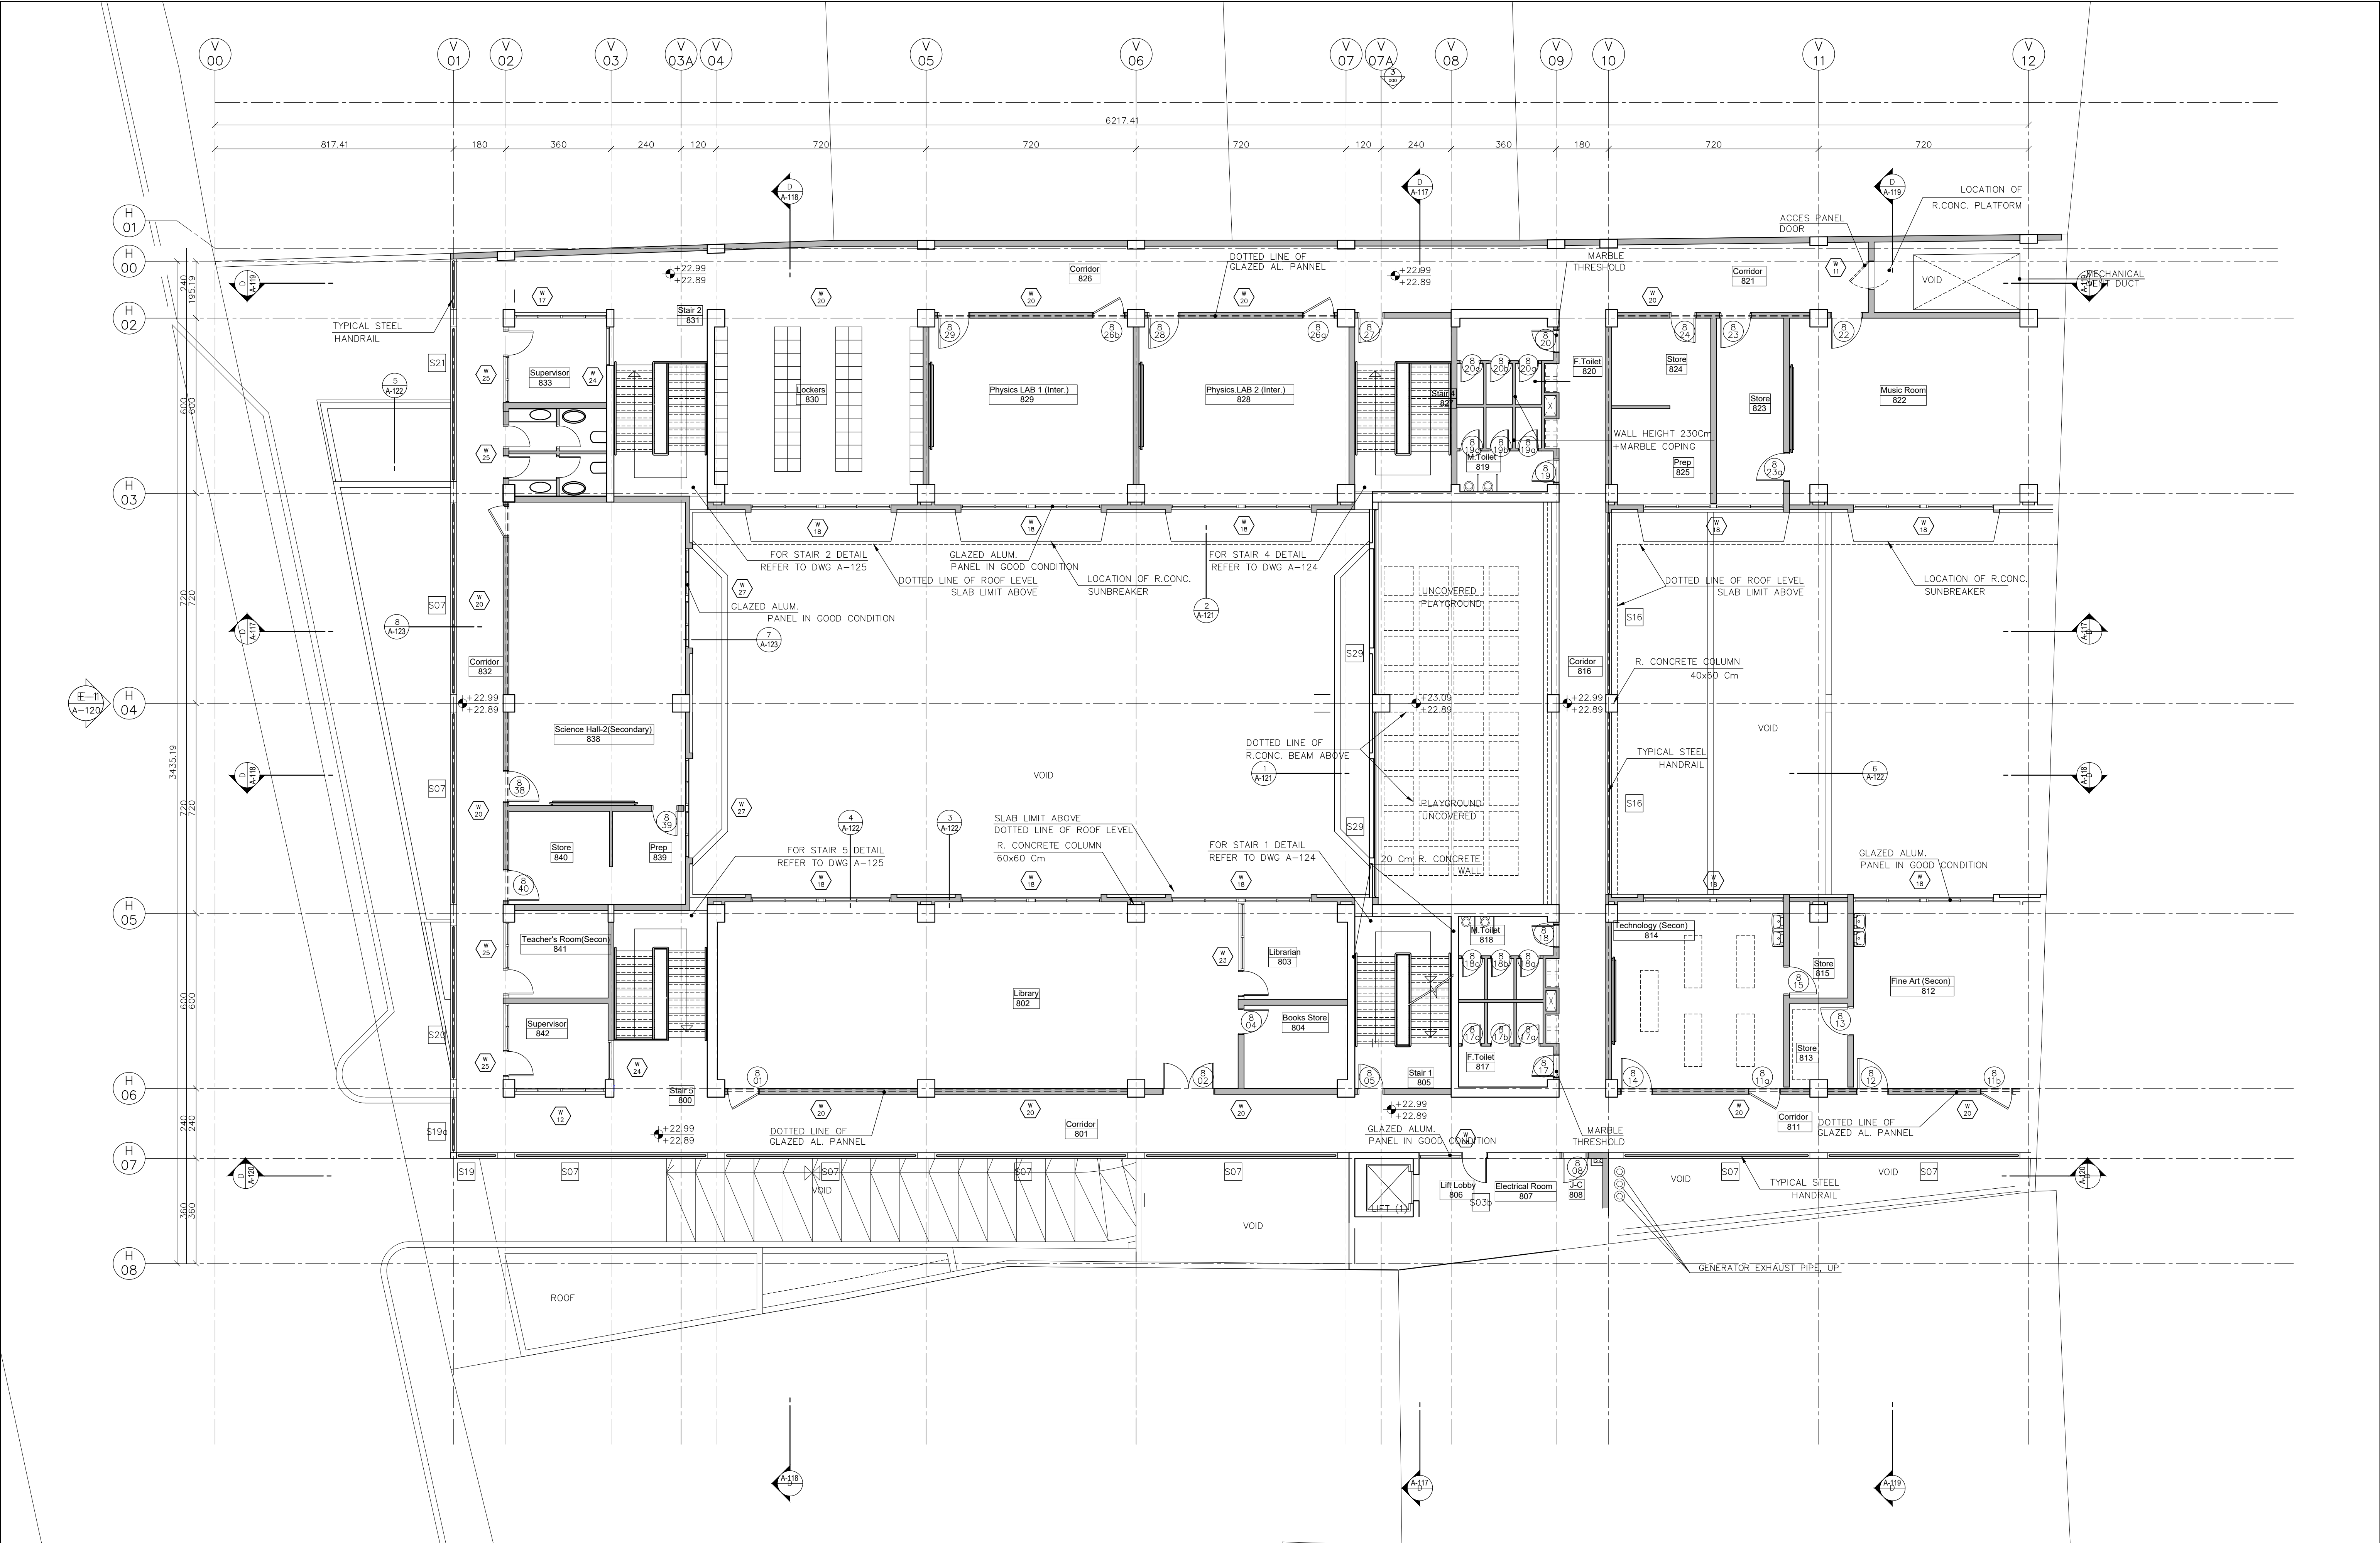

NB: REPRODUCTION AND USE OF THESE DOCUMENTS IS PROHIBITED WITHOUT WRITTEN PERMISSION OF THE DESIGNER

REVISIONS

1 - XXXXX	No.	BY	DATE
2 - XXXXX	Rev1	X.X	X/XX/XX
3 - XXXXX	Rev2	X.X	X/XX/XX
4 - XXXXX	Rev3	X.X	X/XX/XX
5 - XXXXX	Rev4	X.X	X/XX/XX
6 - XXXXX	Rev5	X.X	X/XX/XX
	Rev6	X.X	X/XX/XX

LEGEND

1 - XXXXX
2 - XXXXX
3 - XXXXX
4 - XXXXX
5 - XXXXX
6 - XXXXX

NOTES

1 - XXXXX
2 - XXXXX
3 - XXXXX
4 - XXXXX
5 - XXXXX
6 - XXXXX

سبكتروم للاستشارات الهندسية ش.م.ع.

SPECTRUM ENGINEERING CONSULTANTS s.a.r.l.

TEL: +961 1 345603-345604 - CEL: +961 3 201893 - TELEFAX: +961 1 345605

P.O.BOX: 114/5029 - BEIRUT - LEBANON

http://www.spectrumlb.com E-MAIL: spectrum@spectrumlb.com

BAHRAIN - DUBAI - IRAQ - KUWAIT - KSA - QATAR - RIYADH - UAE

- YEMEN - SUDAN - ALBANIA -

REPUBLIC OF LEBANON

MINISTRY OF EDUCATION & HIGHER EDUCATION

COUNCIL FOR DEVELOPMENT & RECONSTRUCTION

PRE-ELEMENTARY - ELEMENTARY - INTERMEDIATE SCHOOL

ON LOT No. 1230 - BEIRUT

04

LEVEL 8 FLOOR PLAN

SCALE: 1/100

PAPER: A1

DATE: SEP/2026

DRAWN: --

CHECKED: --


APP'D: --

PROJ. No.: L2019-02

DWG. No.: A-012

APP'D FOR CONSTRUCTION:

COMPUTER CODE No. XX-XXXX

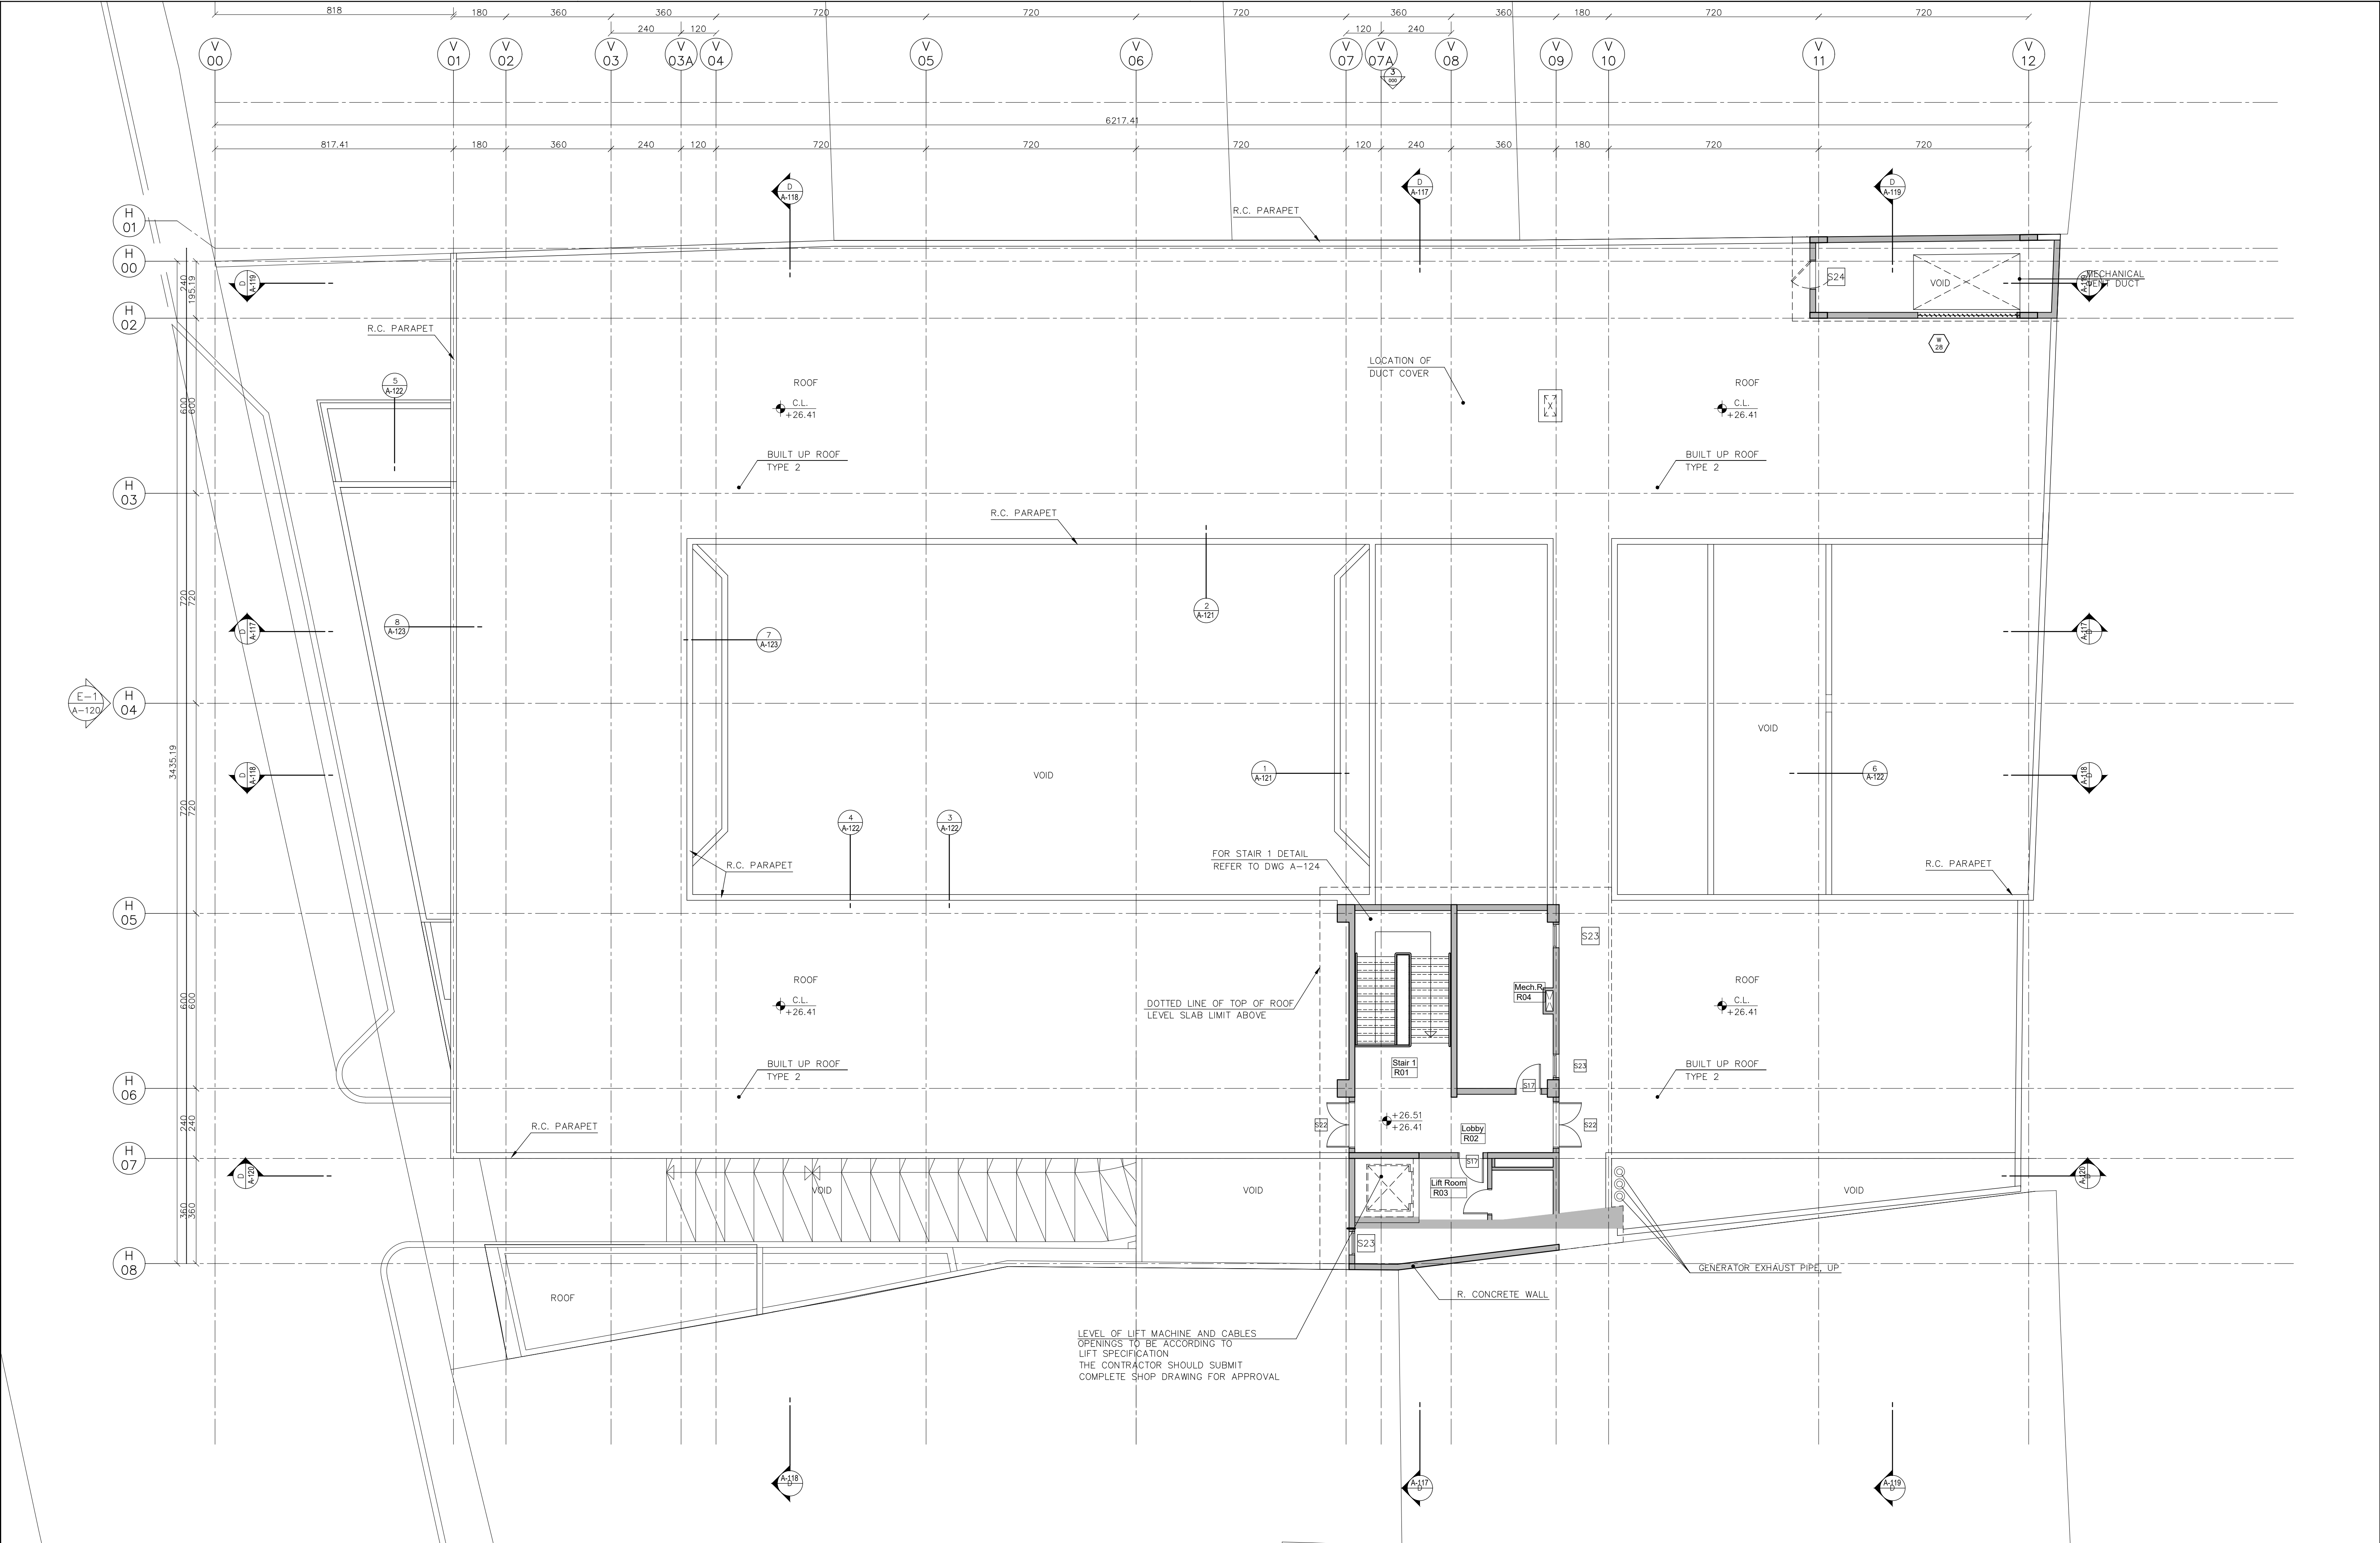

NB: REPRODUCTION AND USE OF THESE DOCUMENTS IS PROHIBITED WITHOUT WRITTEN PERMISSION OF THE DESIGNER

REVISIONS	No.	BY	DATE
1 - XXXXX	Rev1	X.X	X/XX/XX
2 - XXXXX	Rev2	X.X	X/XX/XX
3 - XXXXX	Rev3	X.X	X/XX/XX
4 - XXXXX	Rev4	X.X	X/XX/XX
5 - XXXXX	Rev5	X.X	X/XX/XX
6 - XXXXX	Rev6	X.X	X/XX/XX

LEGEND
1 - XXXXX
2 - XXXXX
3 - XXXXX
4 - XXXXX
5 - XXXXX
6 - XXXXX


NOTES
1 - XXXXX
2 - XXXXX
3 - XXXXX
4 - XXXXX
5 - XXXXX
6 - XXXXX

سبكتروم للاستشارات الهندسية ش.م.ع.
SPECTRUM ENGINEERING CONSULTANTS s.a.r.l.
TEL: +961 1 345603-345604 - CEL: +961 3 201893 - TELEFAX: +961 1 345605
P.O.BOX: 114/5029 - BEIRUT - LEBANON
<http://www.spectrumlb.com> E-MAIL: spectrum@spectrumlb.com
BAHRAIN - DUBAI - IRAQ - KUWAIT - KSA - QATAR - RIYADH - UAE
YEMEN - SUDAN - ALBANIA

REPUBLIC OF LEBANON
MINISTRY OF EDUCATION & HIGHER EDUCATION
COUNCIL FOR DEVELOPMENT & RECONSTRUCTION
PRE-ELEMENTARY - ELEMENTARY - INTERMEDIATE SCHOOL
& SECONDARY SCHOOL ON LOT No. 1230 - BEIRUT 04

ROOF PLAN

SCALE:	1/100	PAPER	A1
DATE:	SEP/2026	DRAWN:	--
CHECKED:	--	APP'D:	--
PROJ. No.:	L2019-02	DWG. No.:	A-013
APP'D FOR CONSTRUCTION :			
COMPUTER CODE No.	XX-XXXX		

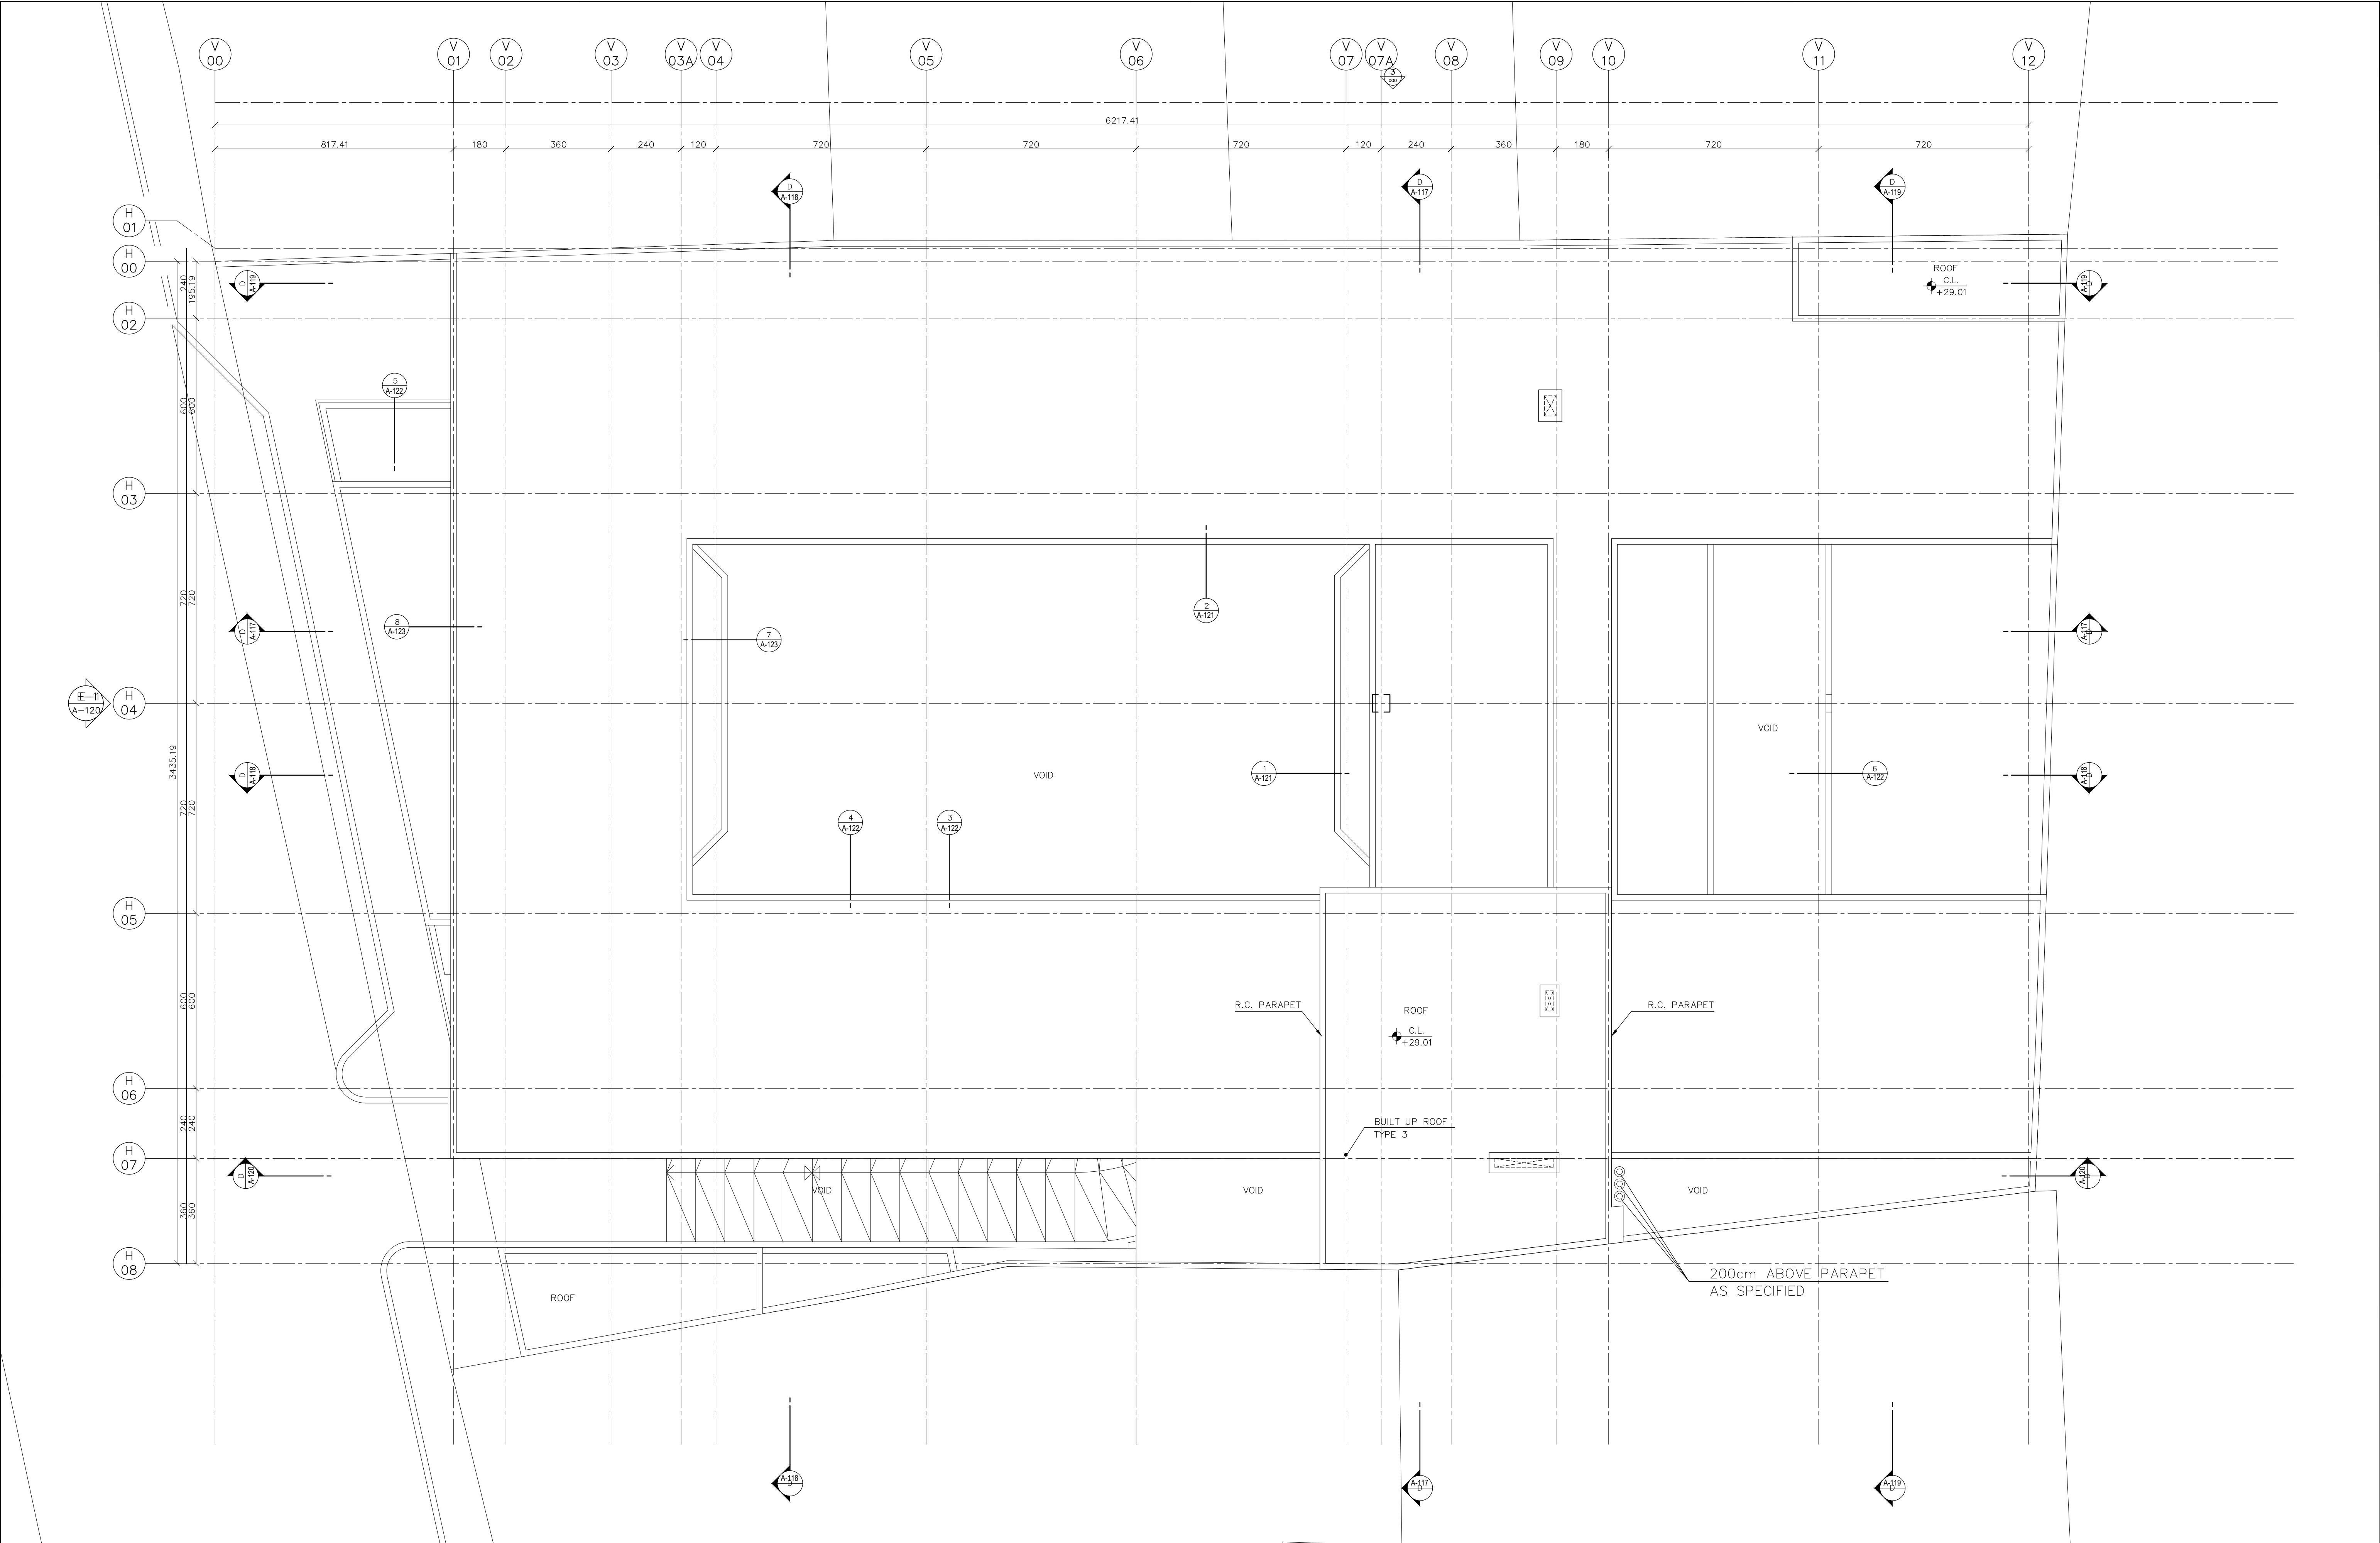

NB: REPRODUCTION AND USE OF THESE DOCUMENTS IS PROHIBITED WITHOUT WRITTEN PERMISSION OF THE DESIGNER

REVISIONS

1 - XXXXX	Rev1	X.X	X/XX/XX
2 - XXXXX	Rev2	X.X	X/XX/XX
3 - XXXXX	Rev3	X.X	X/XX/XX
4 - XXXXX	Rev4	X.X	X/XX/XX
5 - XXXXX	Rev5	X.X	X/XX/XX
6 - XXXXX	Rev6	X.X	X/XX/XX

LEGEND

1 - XXXXX
2 - XXXXX
3 - XXXXX
4 - XXXXX
5 - XXXXX
6 - XXXXX

NOTES

1 - XXXXX
2 - XXXXX
3 - XXXXX
4 - XXXXX
5 - XXXXX
6 - XXXXX

سبكتروم للاستشارات الهندسية ش.م.ل.

SPECTRUM ENGINEERING CONSULTANTS s.a.r.l.

TEL: +961 1 345603-345604 - CEL: +961 3 201893 - TELEFAX: +961 1 345605

P.O.BOX: 114/5029 - BEIRUT - LEBANON

http://www.spectrumlb.com E-MAIL: spectrum@spectrumlb.com

BAHRAIN - DUBAI - IRAQ - KUWAIT - KSA - QATAR - RIYADH - UAE

- YEMEN - SUDAN - ALBANIA -

REPUBLIC OF LEBANON

MINISTRY OF EDUCATION & HIGHER EDUCATION

COUNCIL FOR DEVELOPMENT & RECONSTRUCTION

PRE-ELEMENTARY - ELEMENTARY - INTERMEDIATE SCHOOL

ON LOT No. 1230 - BEIRUT

SCHOOL 04

TOP OF ROOF PLAN

SCALE: 1/100

PAPER: A1

DATE: SEP/2026

DRAWN: --

CHECKED: --

APP'D: --

PROJ. No.: L2019-02

DWG. No.: A-014

APP'D FOR CONSTRUCTION :

COMPUTER CODE No. XX-XXXX



SECTION ELEVATION-1
SCALE 1/100

REVISIONS			
1 - XXXXX	Rev1	X.X	X/XX/XX
2 - XXXXX	Rev2	X.X	X/XX/XX
3 - XXXXX	Rev3	X.X	X/XX/XX
4 - XXXXX	Rev4	X.X	X/XX/XX
5 - XXXXX	Rev5	X.X	X/XX/XX
6 - XXXXX	Rev6	X.X	X/XX/XX

No.	BY	DATE
1	X.X	X/XX/XX
2	X.X	X/XX/XX
3	X.X	X/XX/XX
4	X.X	X/XX/XX
5	X.X	X/XX/XX
6	X.X	X/XX/XX

LEGEND
1 - XXXXX
2 - XXXXX
3 - XXXXX
4 - XXXXX
5 - XXXXX
6 - XXXXX

NOTES
1 - XXXXX
2 - XXXXX
3 - XXXXX
4 - XXXXX
5 - XXXXX
6 - XXXXX

**سبكتروم للاستشارات الهندسية**
SPECTRUM ENGINEERING CONSULTANTS s.a.r.l.
TEL: +961 1 345603-345604 - CEL: +961 3 201893 - TELEFAX: +961 1 345605
P.O. BOX: 114/5029 BEIRUT - LEBANON
http://www.spectrumlb.com E-MAIL: spectrum@spectrumlb.com
BAHRAIN - DUBAI - IRAQ - KUWAIT - KSA - QATAR - RIYADH - UAE
YEMEN - SUDAN - ALBANIA

REPUBLIC OF LEBANON
MINISTRY OF EDUCATION & HIGHER EDUCATION
COUNCIL FOR DEVELOPMENT & RECONSTRUCTION
PRE-ELEMENTARY - ELEMENTARY - INTERMEDIATE SCHOOL
& SECONDARY SCHOOL ON LOT No. 1230 - BEIRUT 04
ELEVATIONS

SCALE: 1/100	PAPER: A1
DATE: SEP/2026	DRAWN: --
CHECKED: --	APP'D: --
PROJ. No.: L2019-02	DWG. No.: A-019
APP'D FOR CONSTRUCTION:	
COMPUTER CODE No.	XX-XXXX